





INDICE

1	PLANO DE UBICACIÓN E IMPLANTACIÓN	3
2	PLANO DE FASES.....	4
3	COMPRESIÓN	5
4	ZONA DE SUMINISTRO (FASE 1).....	6
5	LOSAS Y OBRA CIVIL	7
6	PLANOS COMPRESOR.....	8
6.1	COMPRESOR.....	8
6.2	DIMENSIONES COMPRESOR.....	9
7	PLANOS ESTACION REGULACIÓN Y MEDIDA.....	10
9	PLANO SURTIDOR.....	11
11	BOTELLERO	12
12	ZONAS DE SEGURIDAD	13
13	DIAGRAMA DE GAS	14
14	VISTA EN PLANTA 2	15
15	MARQUESINA	16
16	ZONA REPOSTAJE (FASE 2)	17
17	DISTANCIAS SEGURIDAD Z. REPOSTAJE (FASE 2)	18
18	ZONAS OBRA CIVIL	19
19	TRAZADOS CAMIONES.....	20

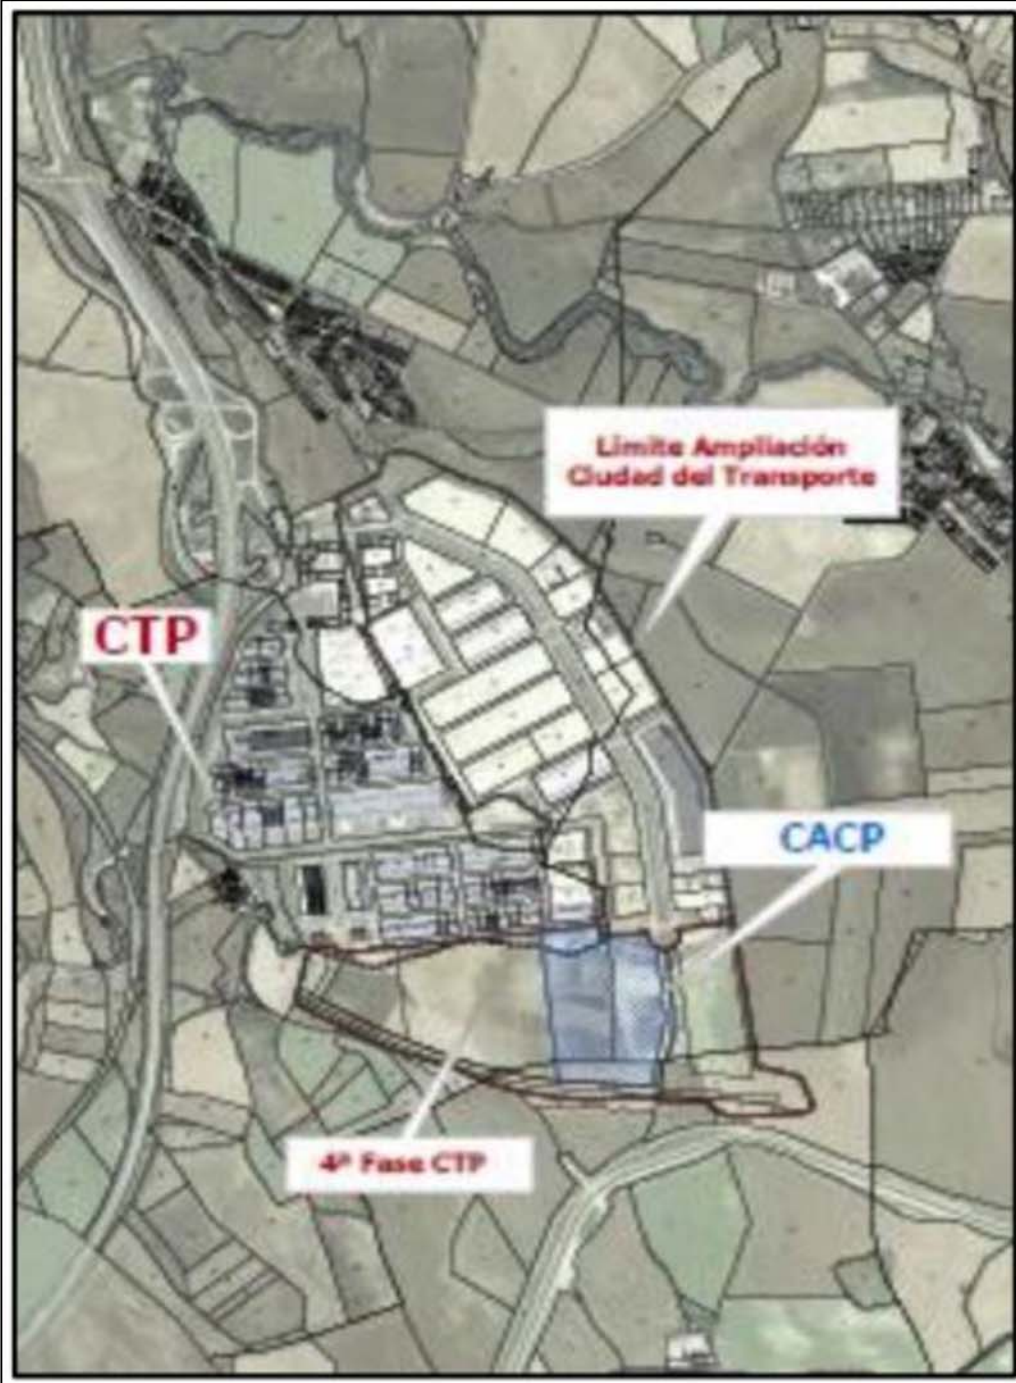

D					--	INTELLECTUAL PROPERTY: ALL RIGHTS RESERVED. DO NOT ALLOW THE USE OR THE TOTAL OR PARTIAL REPRODUCTION OF THIS DOCUMENT OR DISSEMINATION TO THIRD PARTIES WITHOUT PRIOR EXPRESS WRITTEN AUTHORIZATION.		REALIZED BY	CHECKED BY	APPROVED BY	APPROVED FOR CONSTRUCTION
C					--		NAME	--	--	--	--
B					--		DATE	--	--	--	--
A	FIRST EDITION	29/07/22	C.F	R.C	--						
REV.	DESCRIPTION	DATE	REALIZED BY	CHECKED BY	APPROVED BY	PROJECT AND TITLE OF DRAWING					
CONTROL OF CHANGES						31540001CP01 – ESTACIÓN GNC UBIC. E IMPLANT.					
HAM CRIOGÉNICA,S.L. Pol. Ind. Sant Esteban, 4. Parc. 11 08030 - ASERVA (Barcelona) www.ham.es T: +34 93 770 47 60		CUSTOMER MANCOMUNIDAD DE PAMPLONA		FORMAT A2	SCALE S.E		PLANE NUMBER DWG_13_UBICACIÓN E IMPLANTACIÓN	SHEET 1 OF 1		REVIEW A	


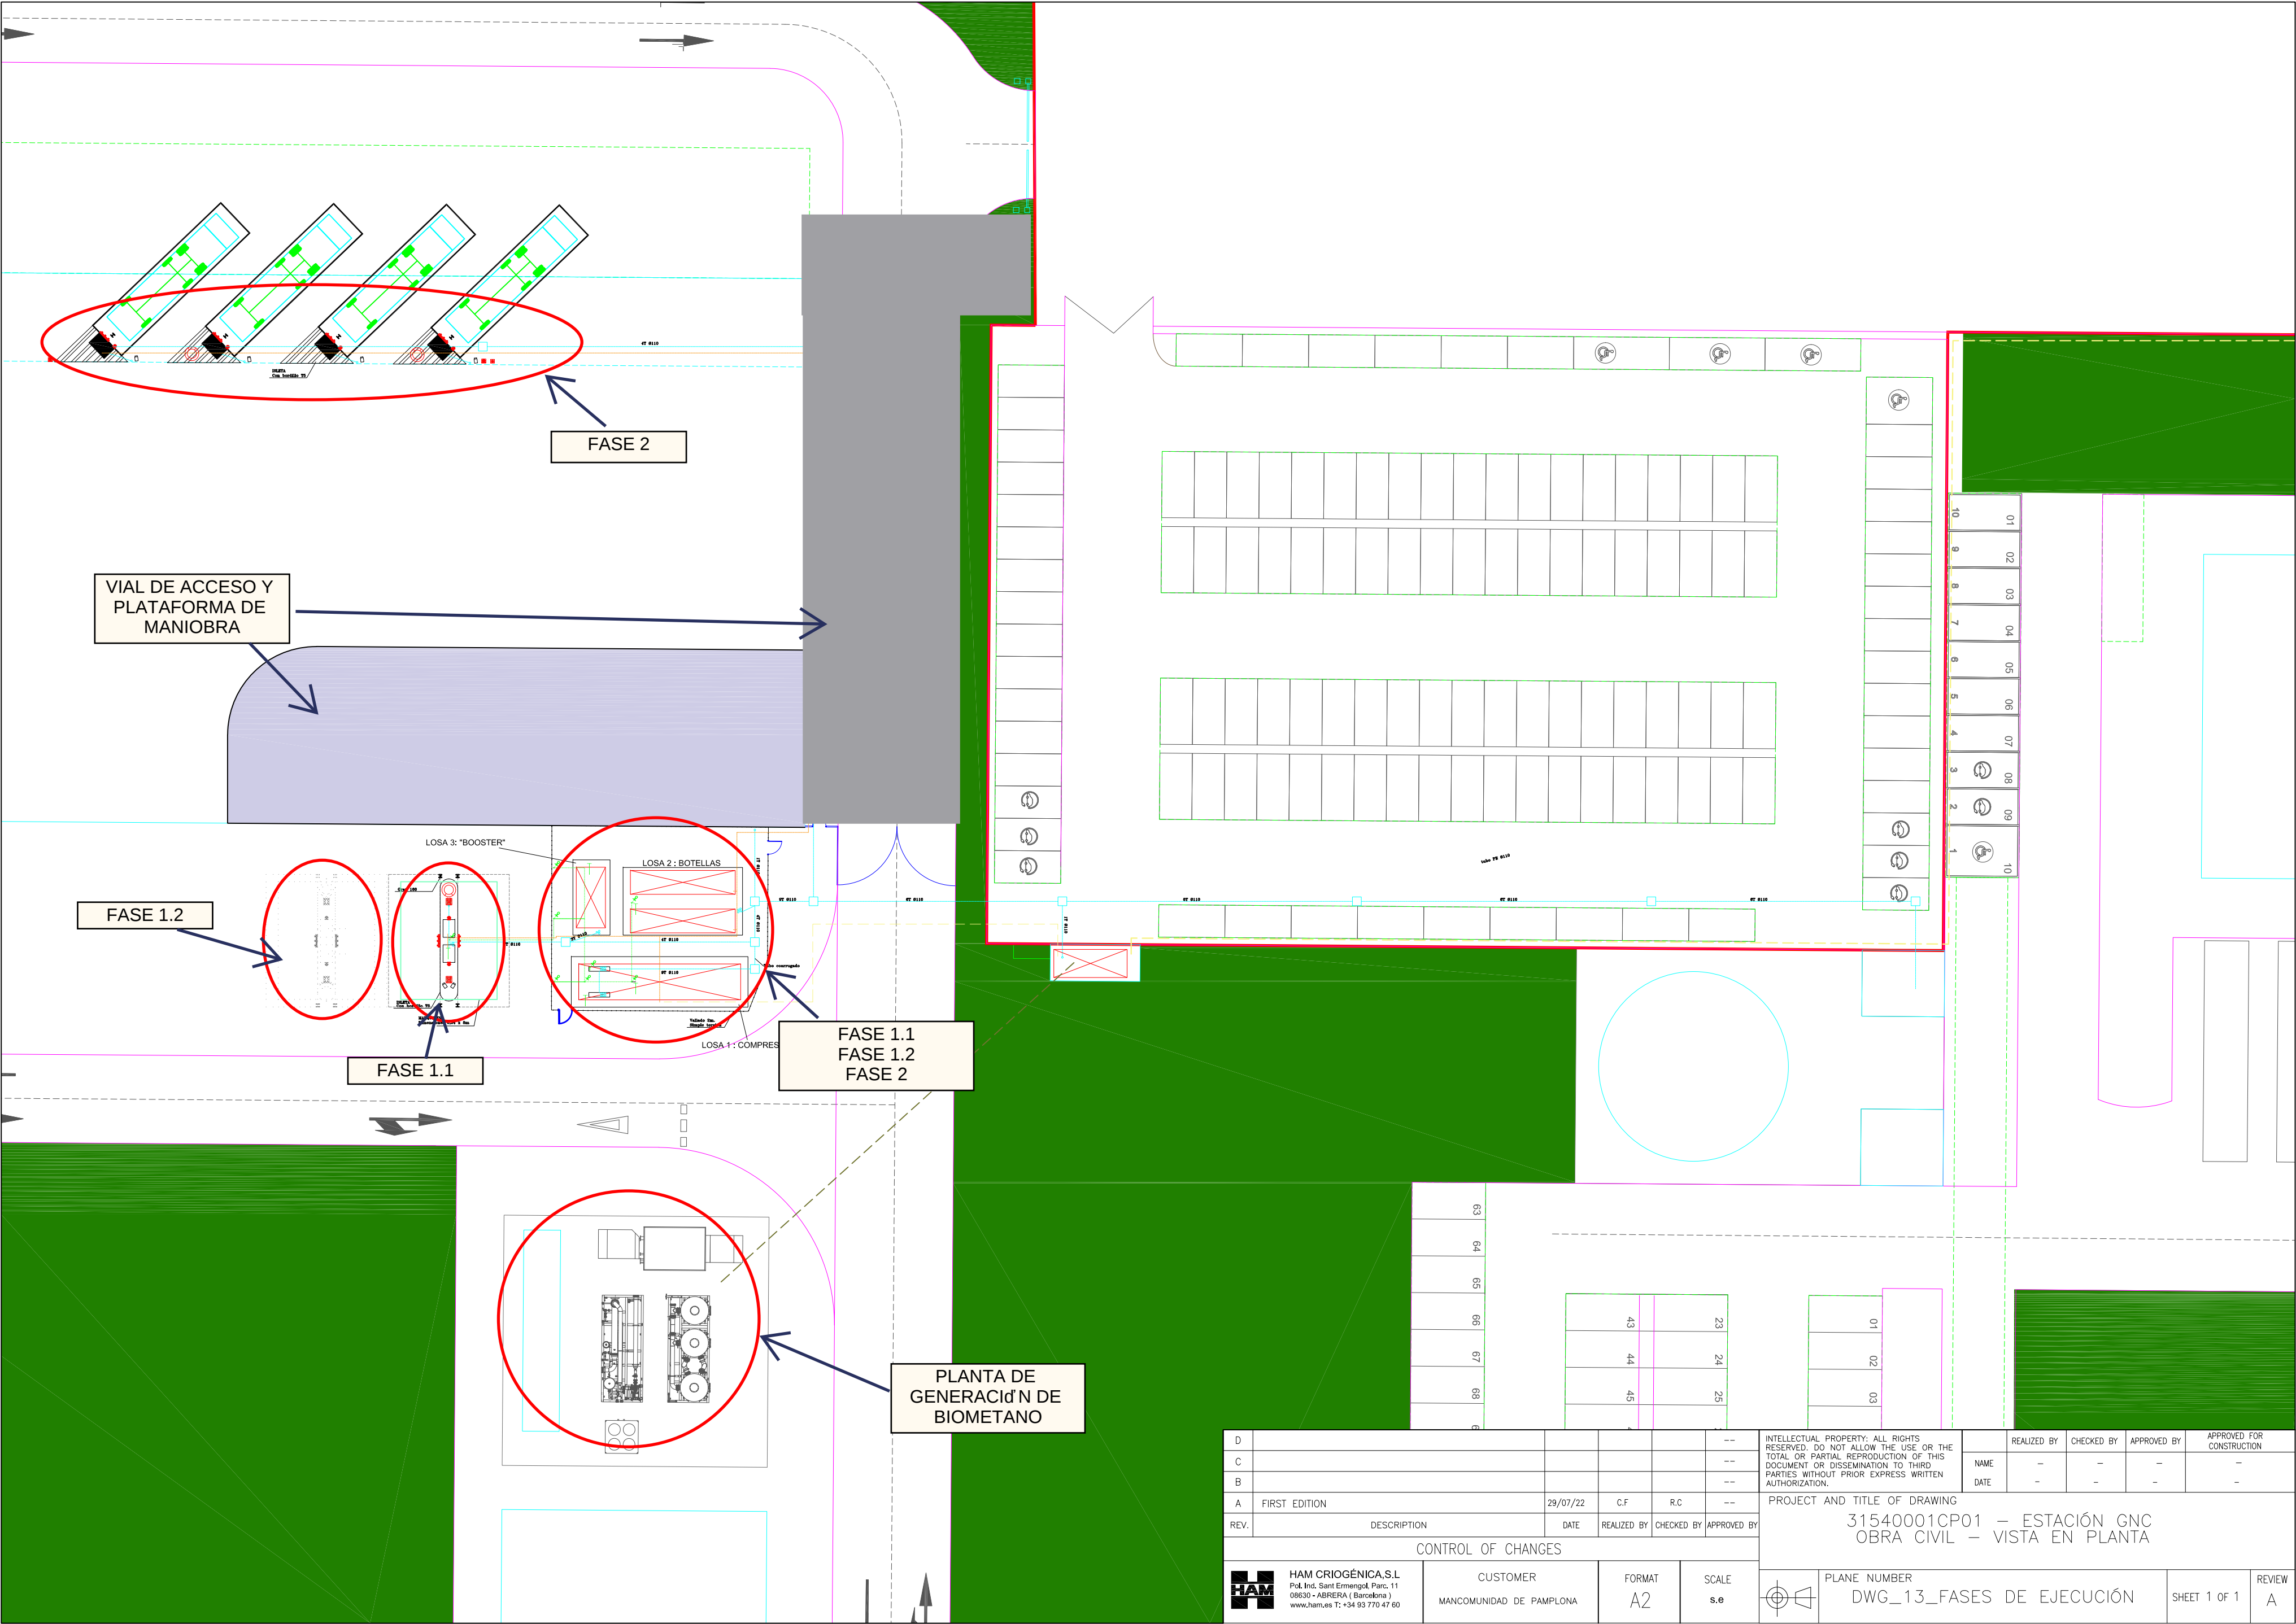


D					--	INTELLECTUAL PROPERTY: ALL RIGHTS RESERVED. DO NOT ALLOW THE USE OR THE TOTAL OR PARTIAL REPRODUCTION OF THIS DOCUMENT OR DISSEMINATION TO THIRD PARTIES WITHOUT PRIOR EXPRESS WRITTEN AUTHORIZATION.		REALIZED BY	CHECKED BY	APPROVED BY	APPROVED FOR CONSTRUCTION
C					--		NAME	-	-	-	-
B					--		DATE	-	-	-	-
A	FIRST EDITION	29/07/22	C.F	R.C	--	PROJECT AND TITLE OF DRAWING					
REV.	DESCRIPTION	DATE	REALIZED BY	CHECKED BY	APPROVED BY	31540001CP01 – ESTACIÓN GNC OBRA CIVIL – VISTA EN PLANTA					
CONTROL OF CHANGES											
 HAM CRIOGÉNICA,S.L Pol.Ind. Sant Ermengol Parc. 11 08030 - ABRERA (Barcelona) www.ham.es T: +34 93 770 47 60		CUSTOMER MANCOMUNIDAD DE PAMPLONA		FORMAT A2	SCALE s.e		PLANE NUMBER DWG_13_FASES DE EJECUCIÓN			SHEET 1 of 1	REVIEW A



PARADA DE EMERGENCIA
ACT. MANUAL SISTEMA CONTRAINCENDIOS
SISTEMA CONTRAINCENDIOS ISLETA
PARADA EMERGENCIA GENERAL
ALM. POLVO ABC SISTEMA CONTRAINCENDIOS
LECTOR DE MATRICULAS
DETECTOR DE GAS
EXTINTOR POLVO ABC
EXTINTOR POLVO ABC



 CANALIZACIÓN GAS NATURAL (ACOMETIDA)
 CANALIZACIÓN GNC
 ACOMETIDA BAJA TENSION

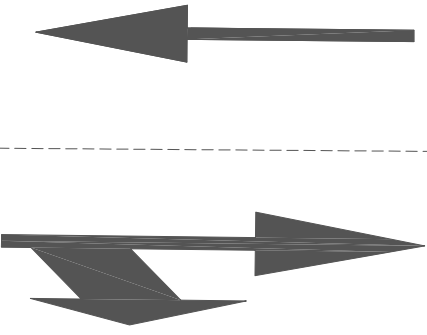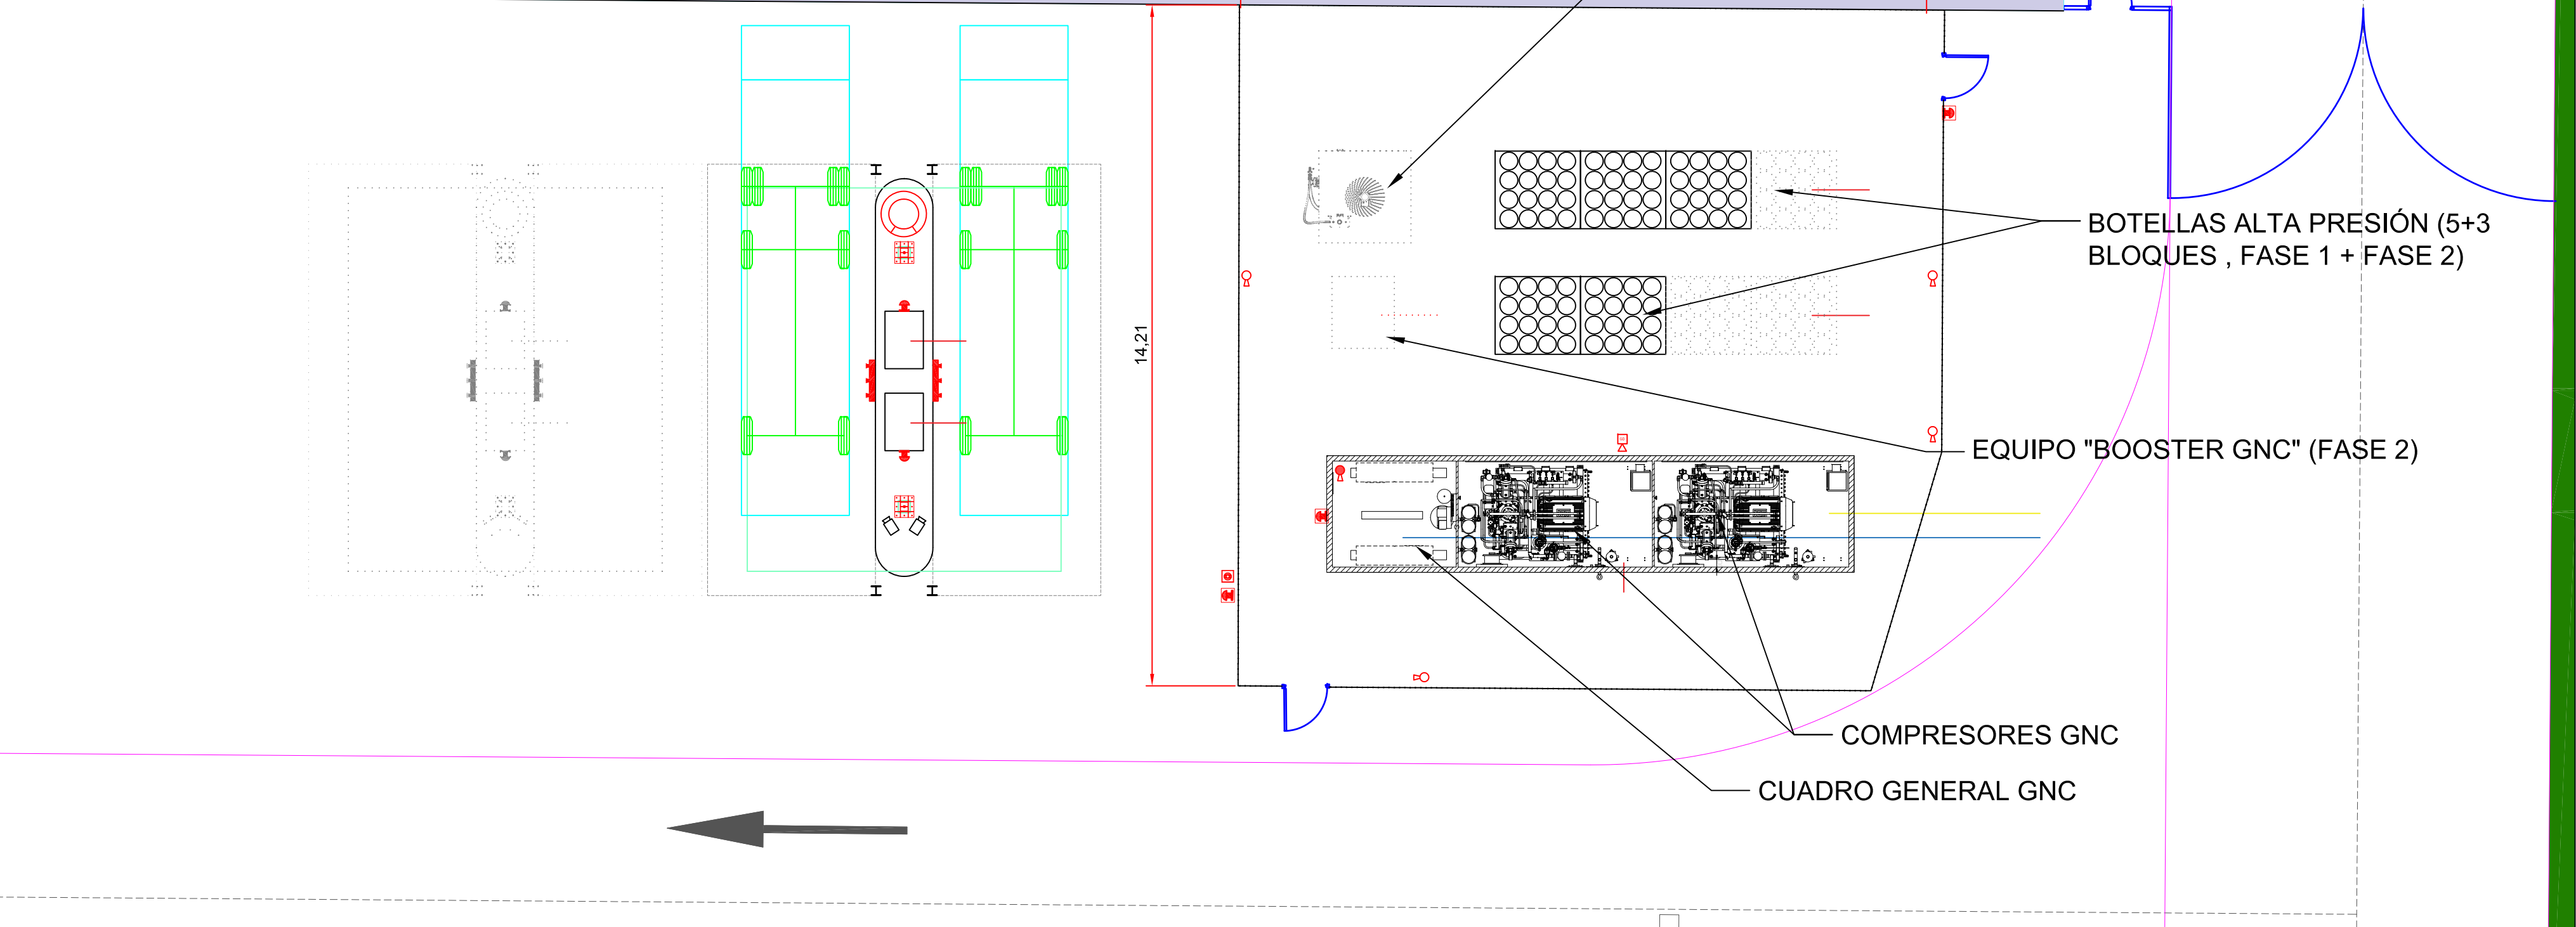

D					--	INTELLECTUAL PROPERTY: ALL RIGHTS RESERVED. DO NOT ALLOW THE USE OR THE TOTAL OR PARTIAL REPRODUCTION OF THIS DOCUMENT OR DISSEMINATION TO THIRD PARTIES WITHOUT PRIOR EXPRESS WRITTEN AUTHORIZATION.		REALIZED BY	CHECKED BY	APPROVED BY	APPROVED FOR CONSTRUCTION
C	ISLETA 2 "PUNTEADA"	29/07/22	C.F	R.C	--		NAME	--	--	--	--
B	DISPOSICIÓN EQUIPOS	27/07/22	C.F	R.C	--		DATE	--	--	--	--
A	FIRST EDITION	13/07/22	C.F	R.C	--	PROJECT AND TITLE OF DRAWING					
REV.	DESCRIPTION	DATE	REALIZED BY	CHECKED BY	APPROVED BY	31540001CP01 – ESTACIÓN GNC ZONA DE COMPRESIÓN (FASE 1 + FASE 2)					
CONTROL OF CHANGES											
	HAM CRIOGÉNICA,S.L Pol.Ind. Sant Ermengol Parc.11 08030 – ABRERA (Barcelona) www.ham.es T: +34 93 770 47 60	CUSTOMER MANCOMUNIDAD DE PAMPLONA	FORMAT A2	SCALE 1/100		PLANE NUMBER DWG_5_COMPRESION	SHEET 1 of 1			REVIEW C	



PARADA DE EMERGENCIA
ACT. MANUAL SISTEMA CONTRAINCENDIOS
SISTEMA CONTRAINCENDIOS ISLETA
PARADA EMERGENCIA GENERAL
ALM. POLVO ABC SISTEMA CONTRAINCENDIOS
LECTOR DE MATRICULAS

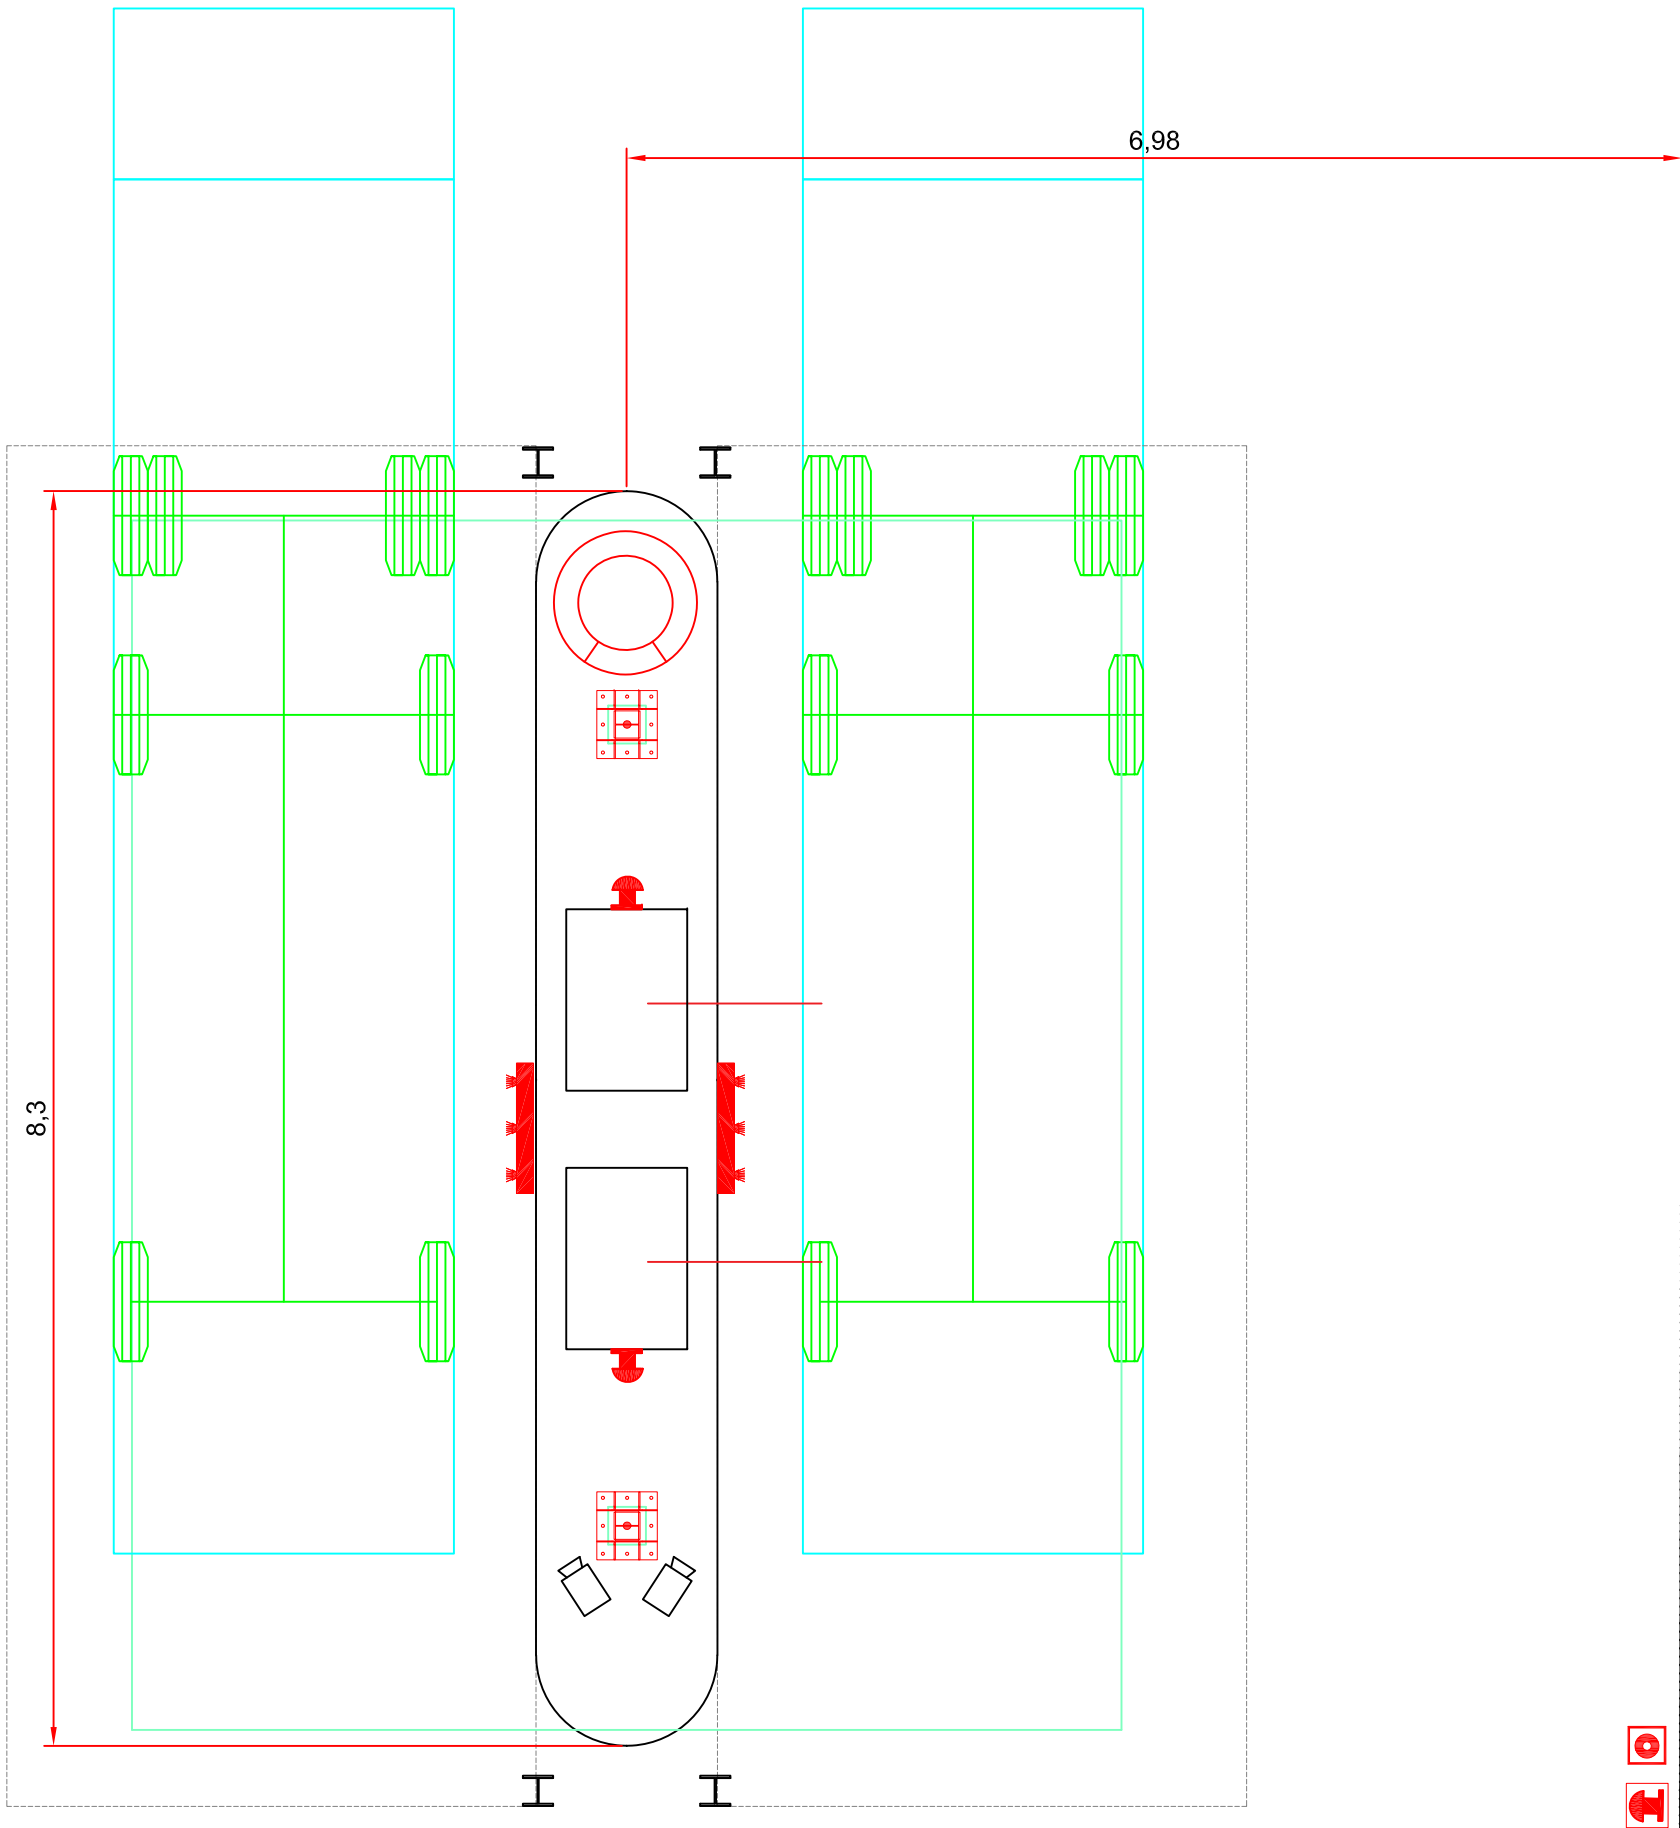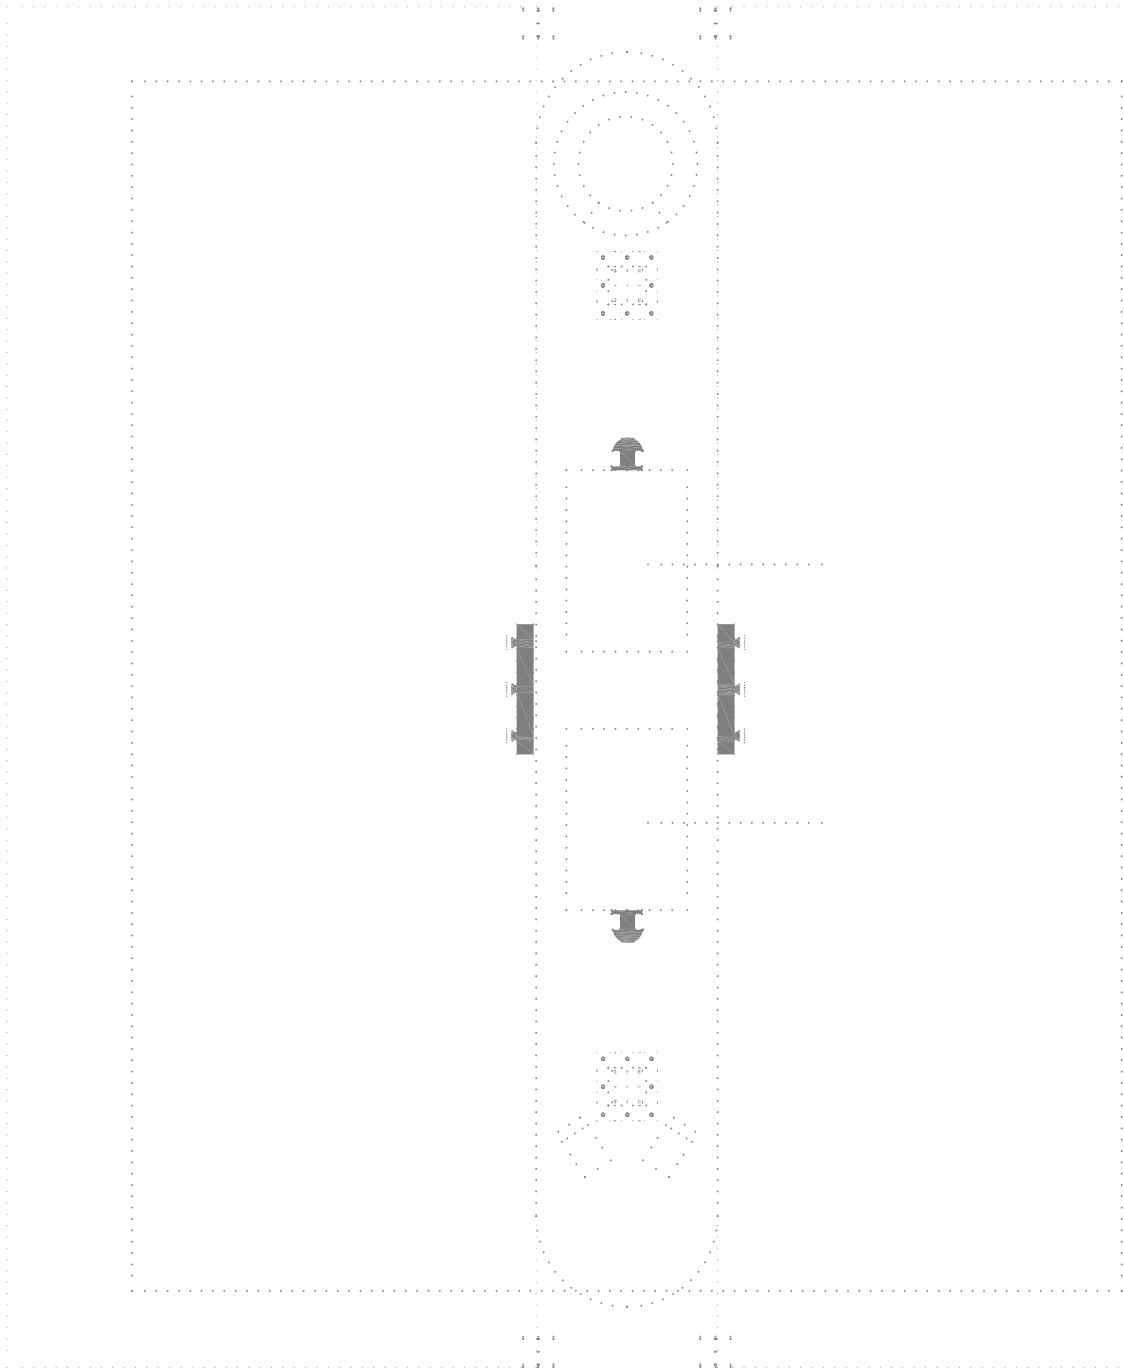

D					--	INTELLECTUAL PROPERTY: ALL RIGHTS RESERVED. DO NOT ALLOW THE USE OR THE TOTAL OR PARTIAL REPRODUCTION OF THIS DOCUMENT OR DISSEMINATION TO THIRD PARTIES WITHOUT PRIOR EXPRESS WRITTEN AUTHORIZATION.		REALIZED BY	CHECKED BY	APPROVED BY	APPROVED FOR CONSTRUCTION
C	ISLETA 2 "PUNTEADA"	29/07/22	C.F	R.C	--		NAME	--	--	--	--
B	SENTIDO DE GIRO + ISLETAS	27/07/22	C.F	R.C	--		DATE	--	--	--	--
A	FIRST EDITION	13/07/22	C.F	R.C	--		PROJECT AND TITLE OF DRAWING				
REV.	DESCRIPTION	DATE	REALIZED BY	CHECKED BY	APPROVED BY	31540001CP01 – ESTACIÓN GNC ZONA DE SUMINISTRO (FASE 1)					
CONTROL OF CHANGES											
	HAM CRIOGÉNICA,S.L Pol.Ind. Sant Ermengol Parc. 11 08030 - ADRERA (Barcelona) www.ham.es T: +34 93 770 47 60	CUSTOMER MANCOMUNIDAD DE PAMPLONA	FORMAT A2	SCALE 1/50		PLANE NUMBER				SHEET 1 of 1	REVIEW C
						DWG_3_SUMINISTRO					

NOTA: ADAPTAR LOSAS A A EQUIPOS FINALES INSTALADOS

LEYENDA T.T.

Piqueta de cobre 2m. Ø14mm.

Conexión del cable soldada

Punta exterior de conexión
Cu 35mm²


Cable cobre desnudo y trenzado

Zanja eléctrica

Conductos GNC

Conductos Gas Natural

T Coarrugado con guía diametro 110mm

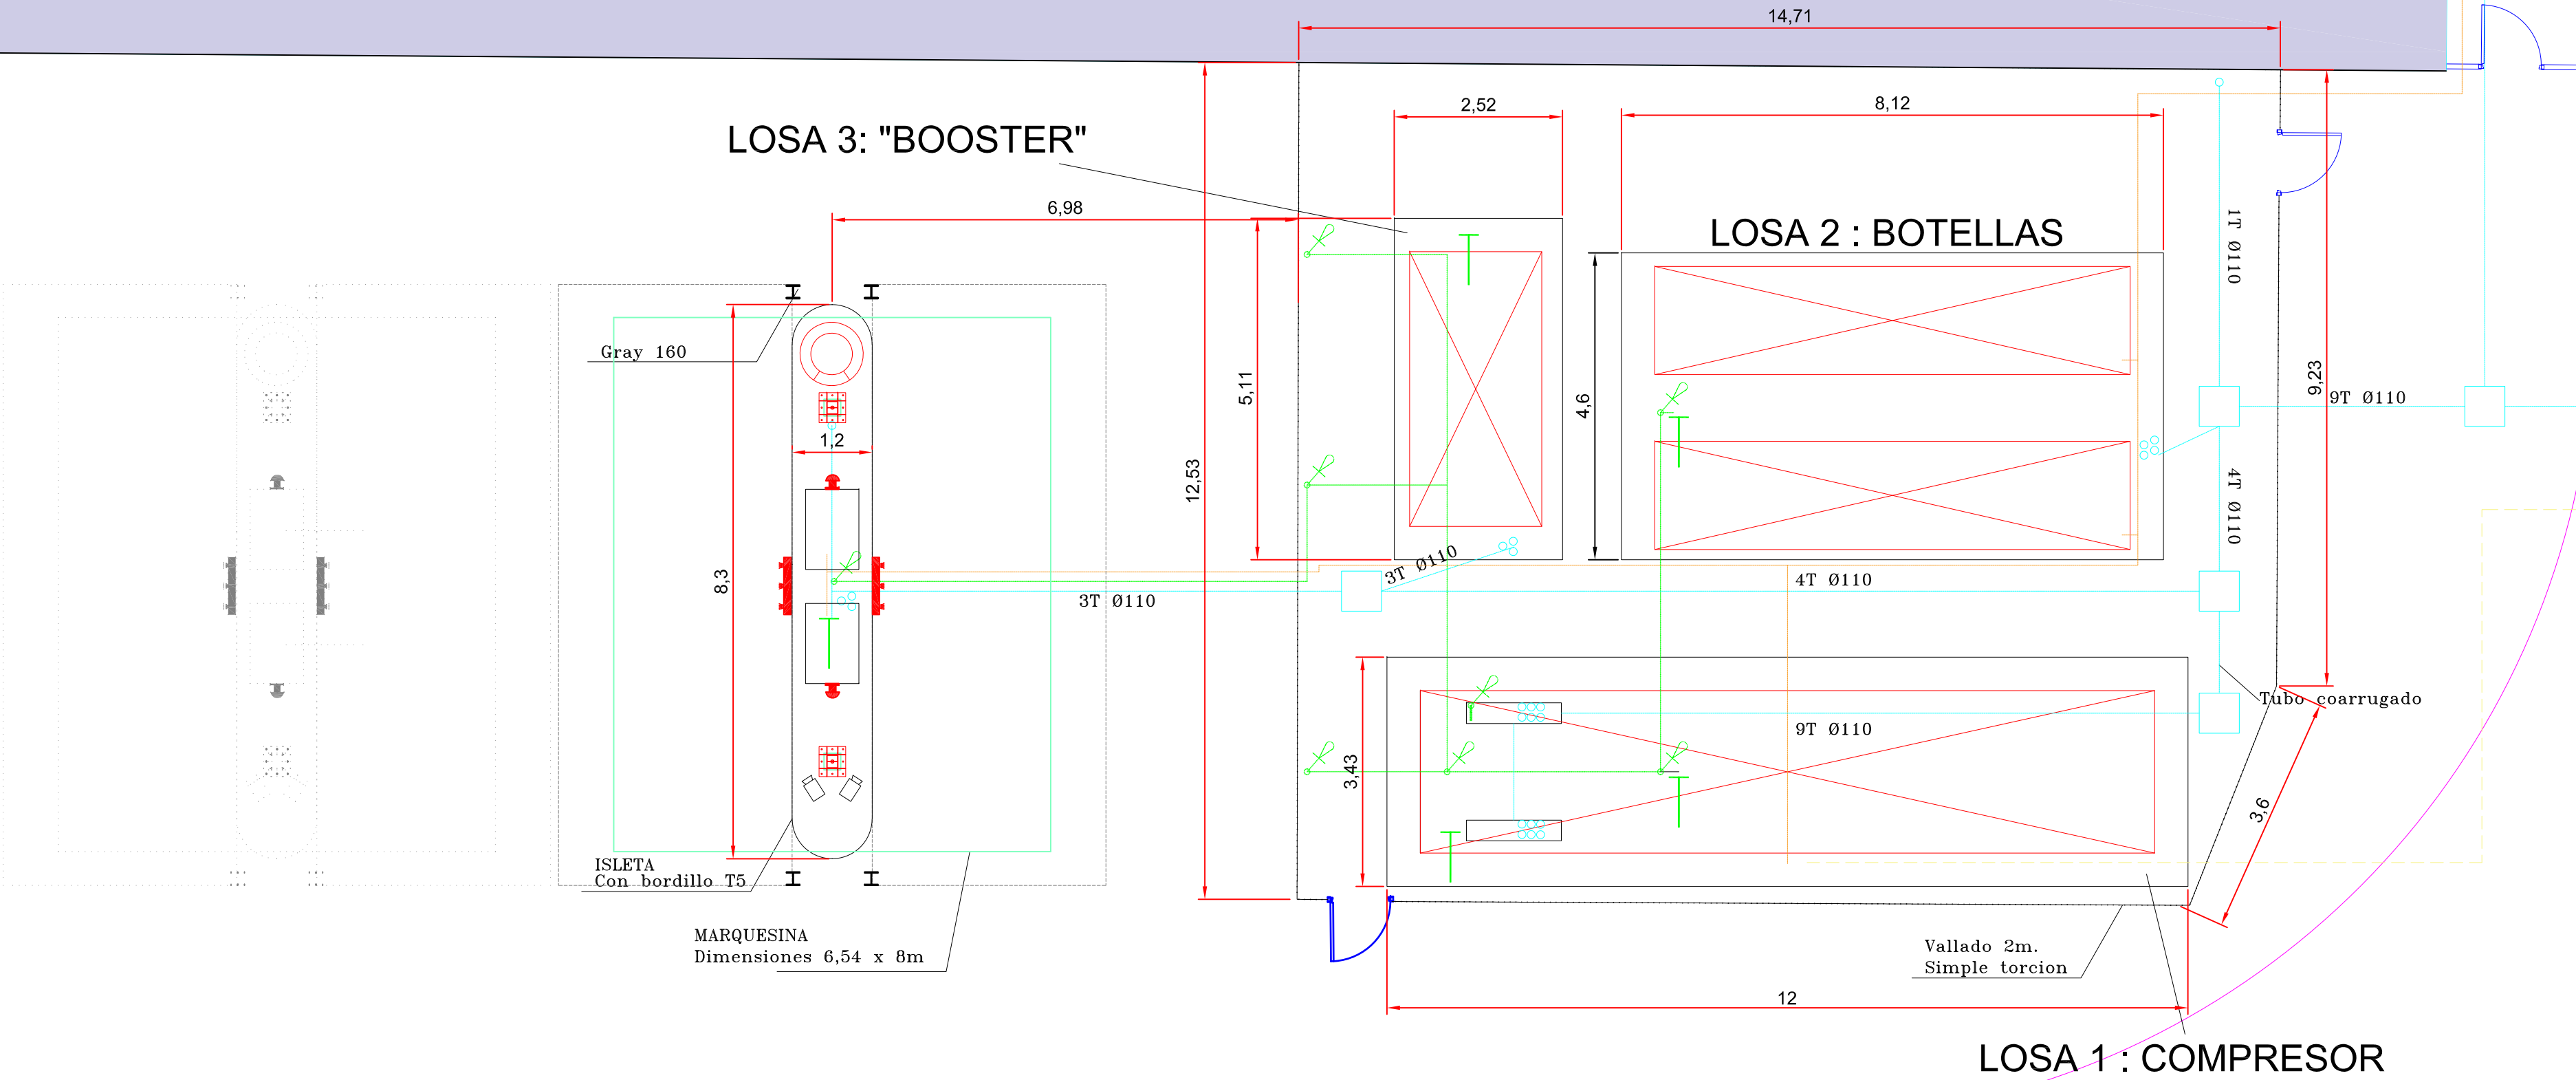


D					--	INTELLECTUAL PROPERTY: ALL RIGHTS RESERVED. DO NOT ALLOW THE USE OR THE TOTAL OR PARTIAL REPRODUCTION OF THIS DOCUMENT OR DISSEMINATION TO THIRD PARTIES WITHOUT PRIOR EXPRESS WRITTEN AUTHORIZATION.	REALIZED BY	CHECKED BY	APPROVED BY	APPROVED FOR CONSTRUCTION	
C					--		NAME	--	--	--	--
B	MODIFICADO SENTIDO MARCHA + OTROS	27/07/22	C.F	R.C	--		DATE	--	--	--	--
A	FIRST EDITION	13/07/22	C.F	R.C	--	PROJECT AND TITLE OF DRAWING					
REV.	DESCRIPTION	DATE	REALIZED BY	CHECKED BY	APPROVED BY	31540001CP01 – ESTACIÓN GNC OBRA CIVIL EQUIPOS					
CONTROL OF CHANGES							PLANE NUMBER	DWG_9_O.C		SHEET 1 OF 1	REVIEW B
 HAM CRIOGÉNICA,S.L. Pol.Ind. Sant Ermengol Parc.11 08030 - ABRERA (Barcelona) www.ham.es T: +34 93 770 47 60		CUSTOMER MANCOMUNIDAD DE PAMPLONA		FORMAT A2	SCALE S.E						



Criogénica


Poigono Industrial Sant Emengol, parcela 11
08630 Abrera (Barcelona)
Tel. 93 770 47 60
Fax 93 770 34 41
ham@ham.es

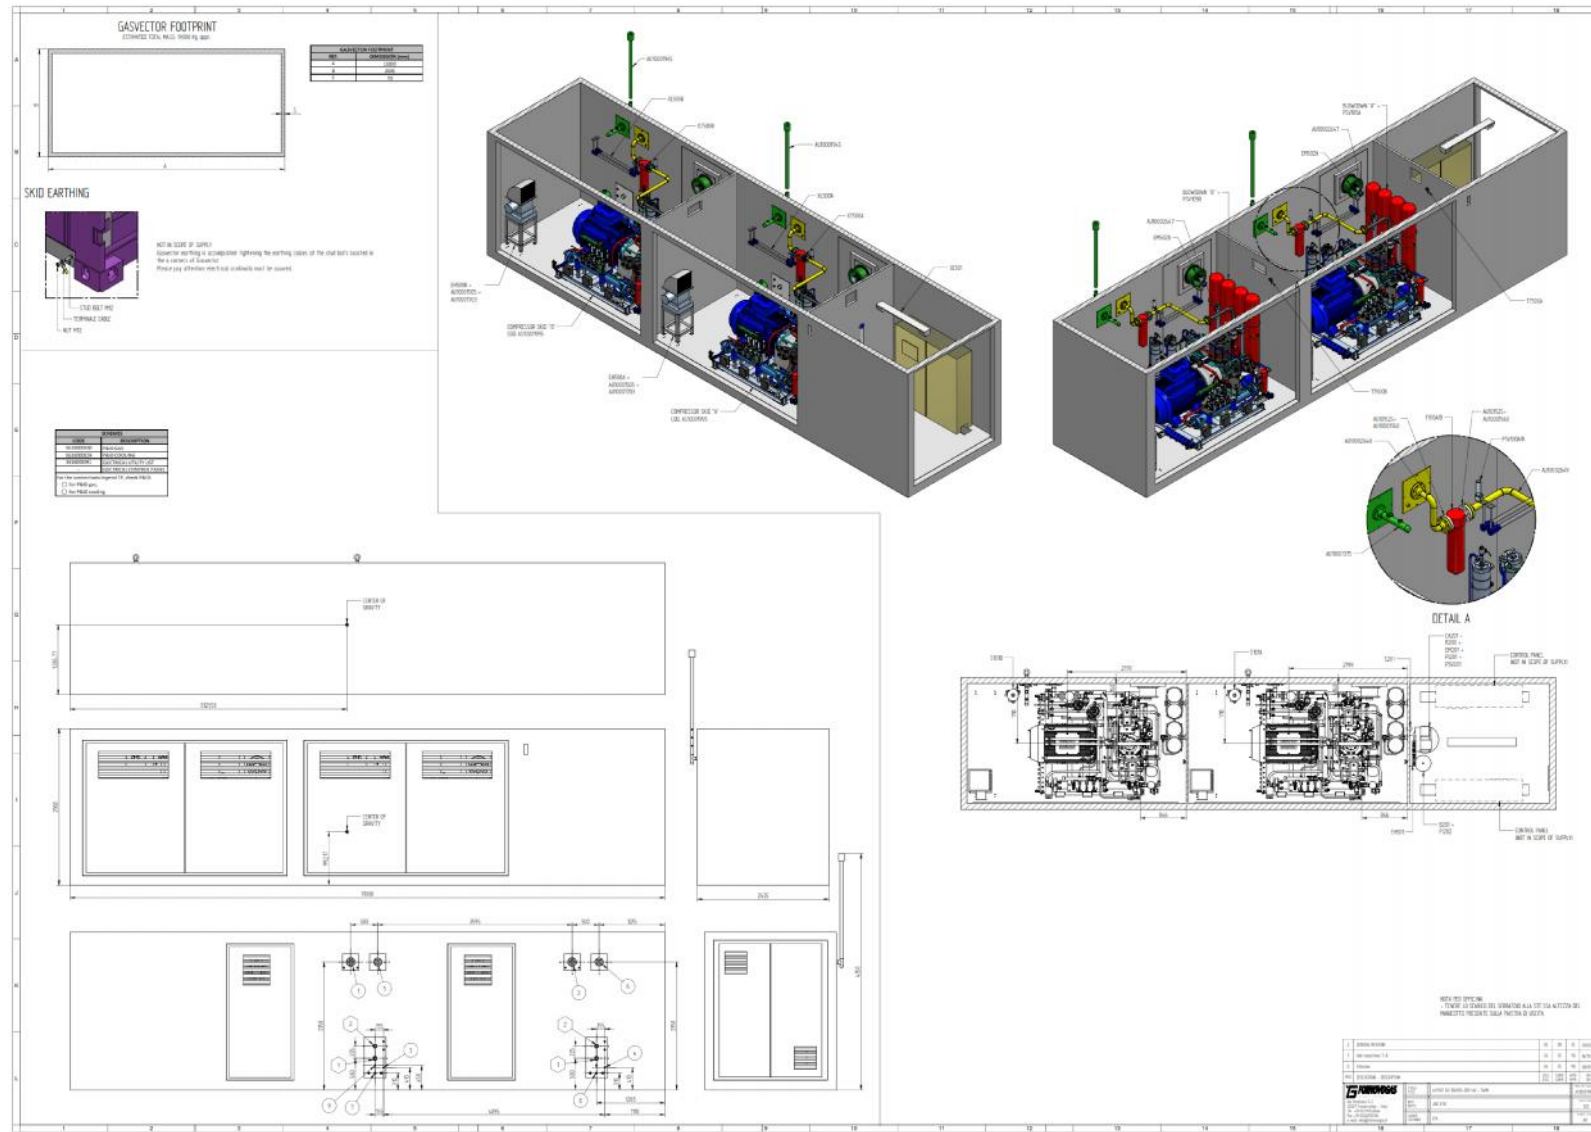



Criogénica

Polígono Industrial Sant Emengol, parcel·la 11
08630 Abrera (Barcelona)
Tel. 93 770 47 60
Fax 93 770 34 41
ham@ham.es

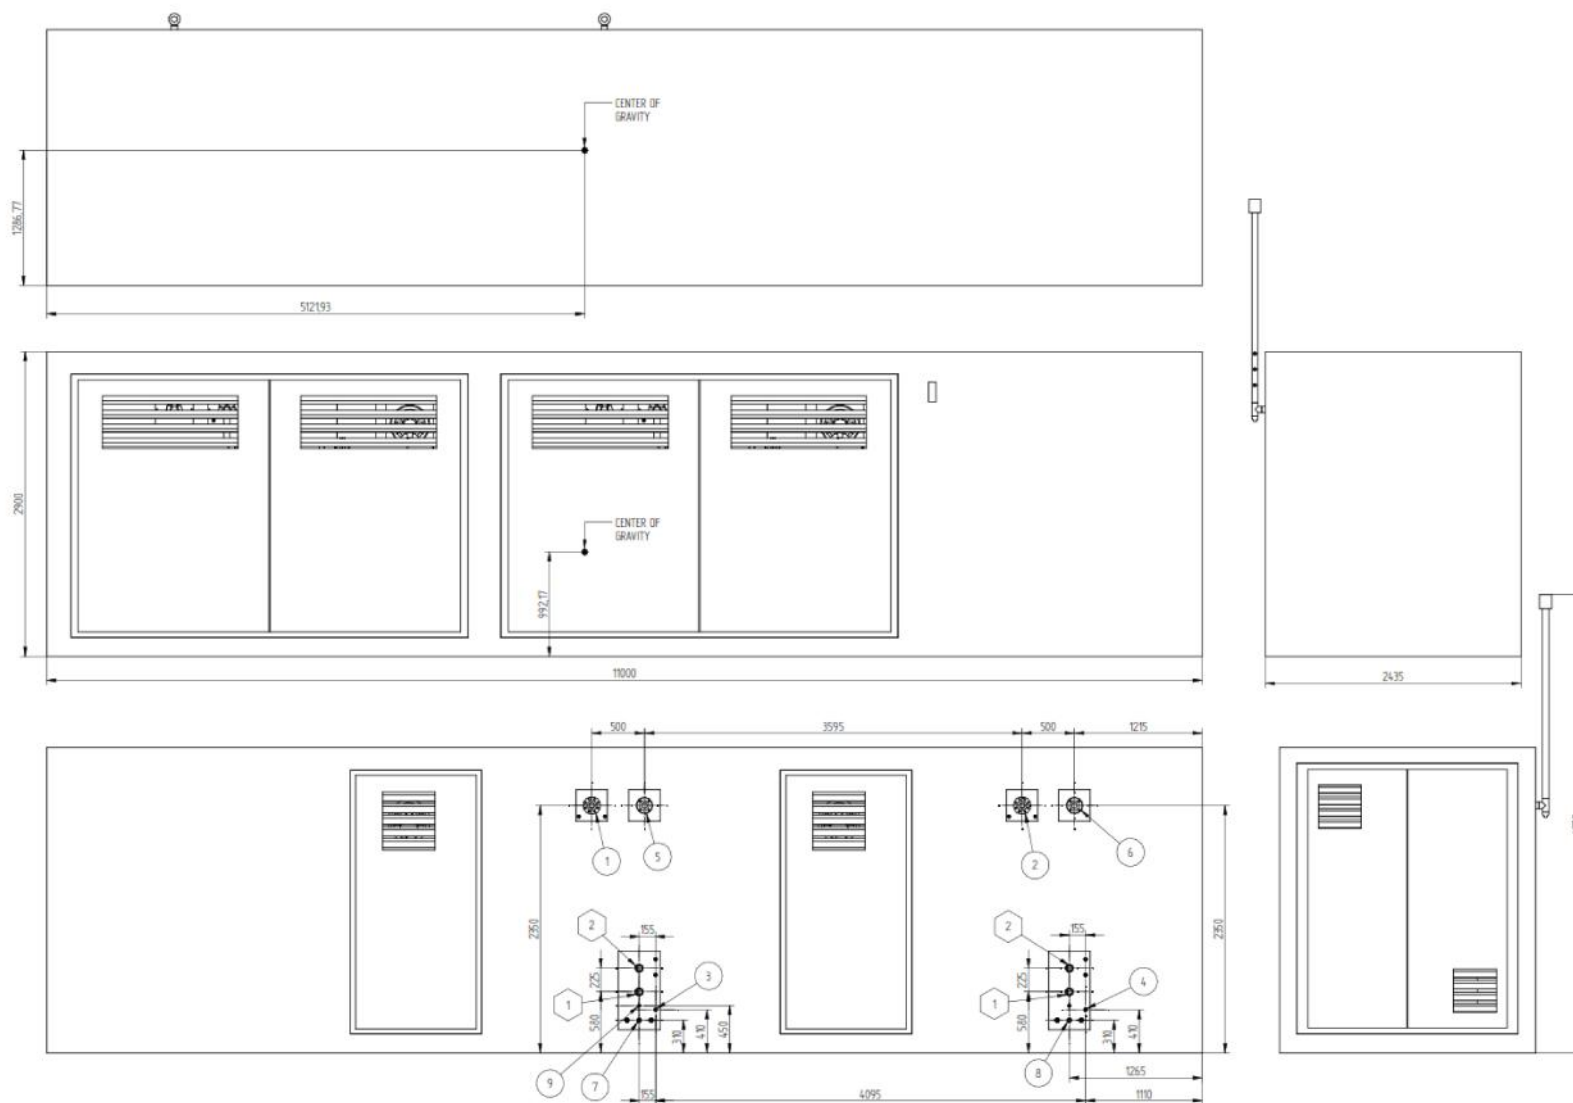





Criogénica

Poigono Industrial Sant Emengol, parcela 11
08630 Abrera (Barcelona)
Tel. 93 770 47 60
Fax 93 770 34 41
ham@ham.es


VISTA LATERAL IZQUIERDA

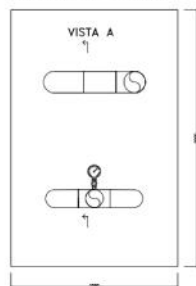


VISTA FRONTAL

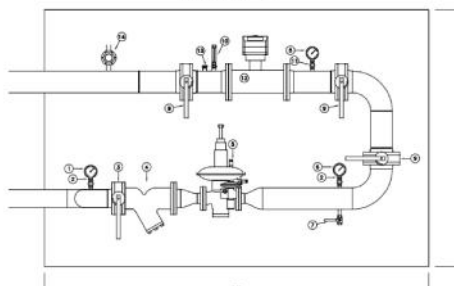


VISTA LATERAL DERECHA

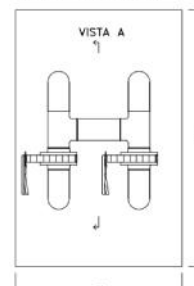


VISTA EN PLANTA LINEAS DE REGULACIÓN

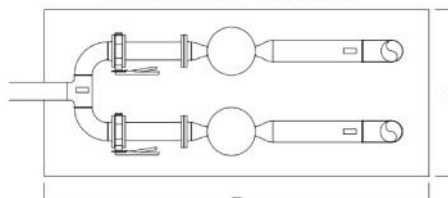

VISTA FRONTAL LINEAS TRASERAS

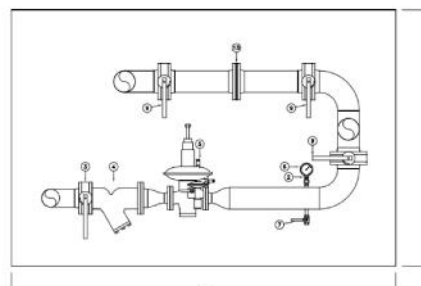

VISTA EN PLANTA UNIDAD DE MEDIDA

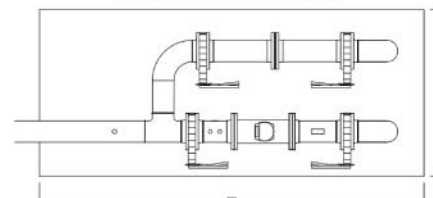


ERM con regulador de
presión redundante

14	VE	-	25	5	Rosa.
13	DECO EN UME	-	150	16	Br.
12	CONTADOR TURBINA C1000 (long.480mm)	-	150	16	Rosa.
11	VALVULA DE 3 VÍAS-ENCH. Y TAPON	-	15	16	Rosa.
10	TORNILLO	-	15	16	Br.
9	VALVULA DE BARRERA	-	150	16	Br.
8	MANOMETRO ESP-100 0-4 bar G1/2	-	15	16	Rosa.
7	VALVULA DE BOLA	-	15	5	Rosa.
6	MANOMETRO ESP-100 0-4 bar	-	15	16	Rosa.
5	REGULADOR DE GAS NORMAL	-	100	16	Br.
4	FILTRO GAS	-	125	6	Br.
3	VALVULA DE BARRERA	-	125	16	Br.
2	VALVULA DE AFRAQUILADA Metl	-	15	16	Rosa.
1	MANOMETRO ESP-100 0-6 bar	-	15	16	Rosa.
POS.	CONCEPTO	MARCA	DN	PN	CUNCL
CLIENTE					
HAM CRIOGENICA					
ESTACION DE REGULACION					
DIMENSIONADO Y POSICIONADO					
Fecha		Módulo		V. F.	
22/06/2022		S/M		J.M.L.	
Revisión		Diseño		Revisión	
PTD 4171		S/E		Técnico	




Criogénica

Polígono Industrial Sant Emengol, parcel·la 11
08630 Abrera (Barcelona)
Tel. 93 770 47 60
Fax 93 770 34 41
ham@ham.es

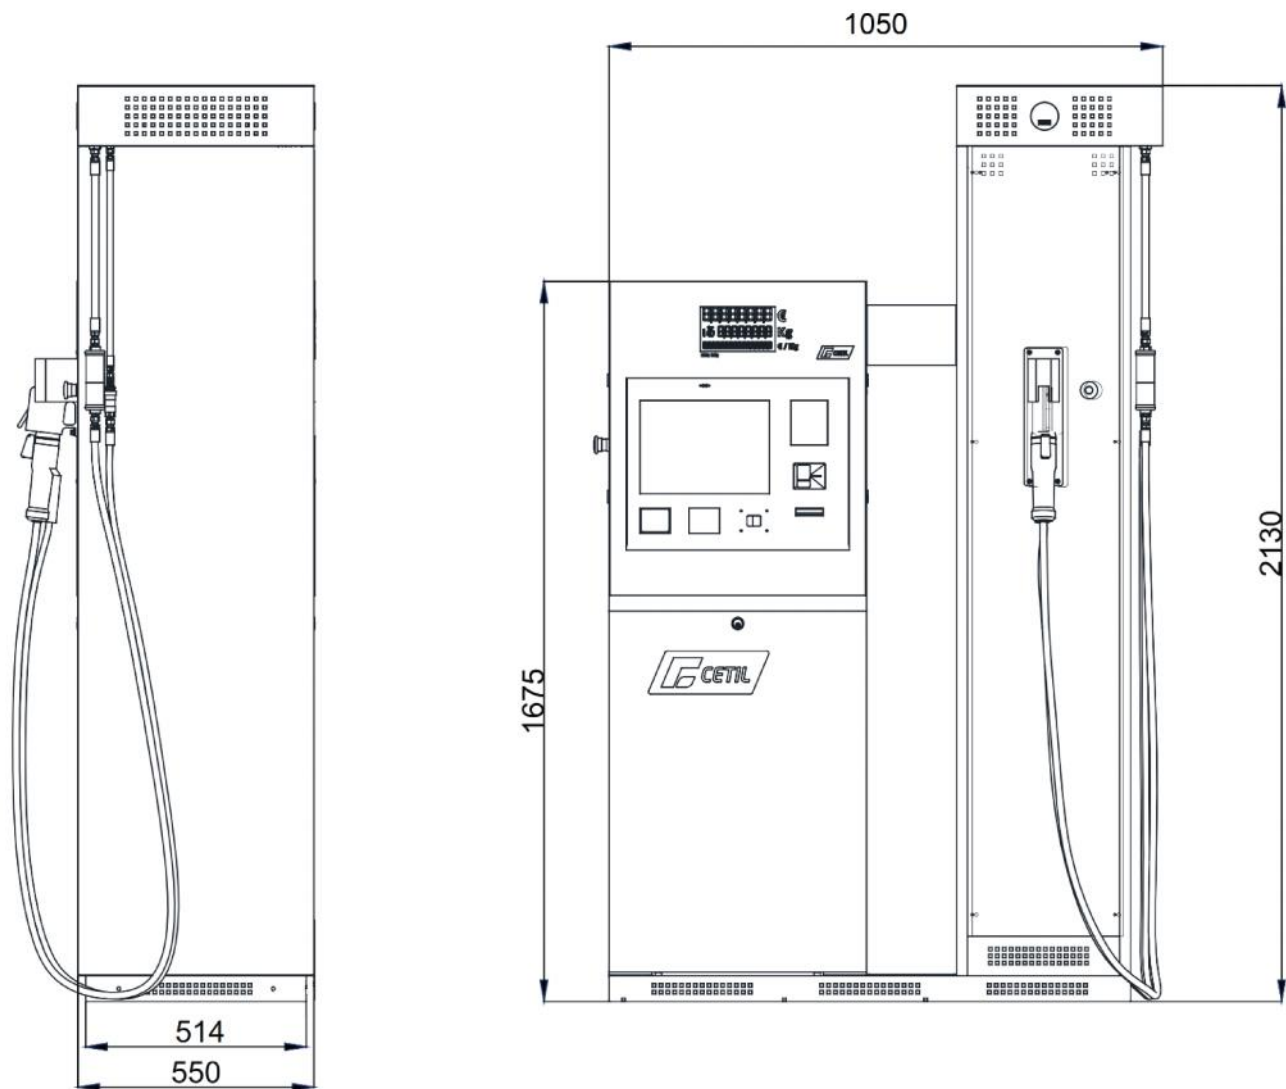

Surtidor de GNC con manguera simple, pistola NGV1

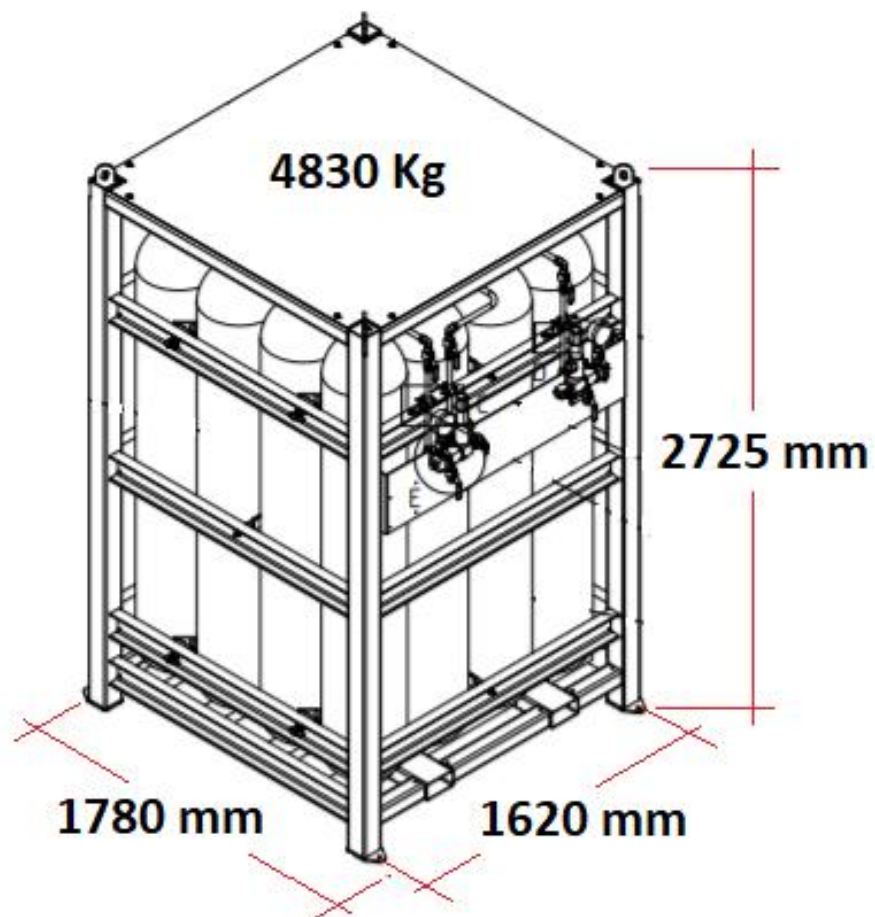

Botellero con 16 botellas de 180 litros,
2880 litros en total



ZONA 1
-Interior cabina



ZONA 2
-2 metros en las oberturas de la cabina zona compresion
-3 metros en las aberturas de las cabinas en la zona almacenamiento.
-Ventoeo 3mts

NOTA: - Depósito y equipos con sistema de puesta a tierra < 20 ohms.
- Material eléctrico situado en zona clasificada del grupo IIA



PARADA DE EMERGENCIA



ACT. MANUAL SISTEMA CONTRAINCENDIOS



SISTEMA CONTRAINCENDIOS ISLETA



PARADA EMERGENCIA GENERAL



ALM. POLVO ABC SISTEMA CONTRAINCENDIOS



LECTOR DE MATRICULAS






DETECTOR DE GAS






EXTINTOR POLVO ABC




EXTINTOR POLVO ABC

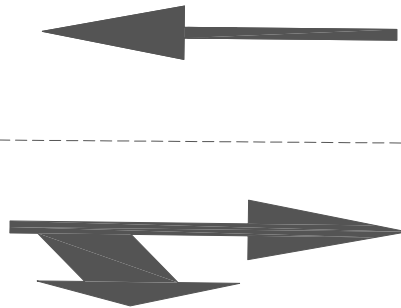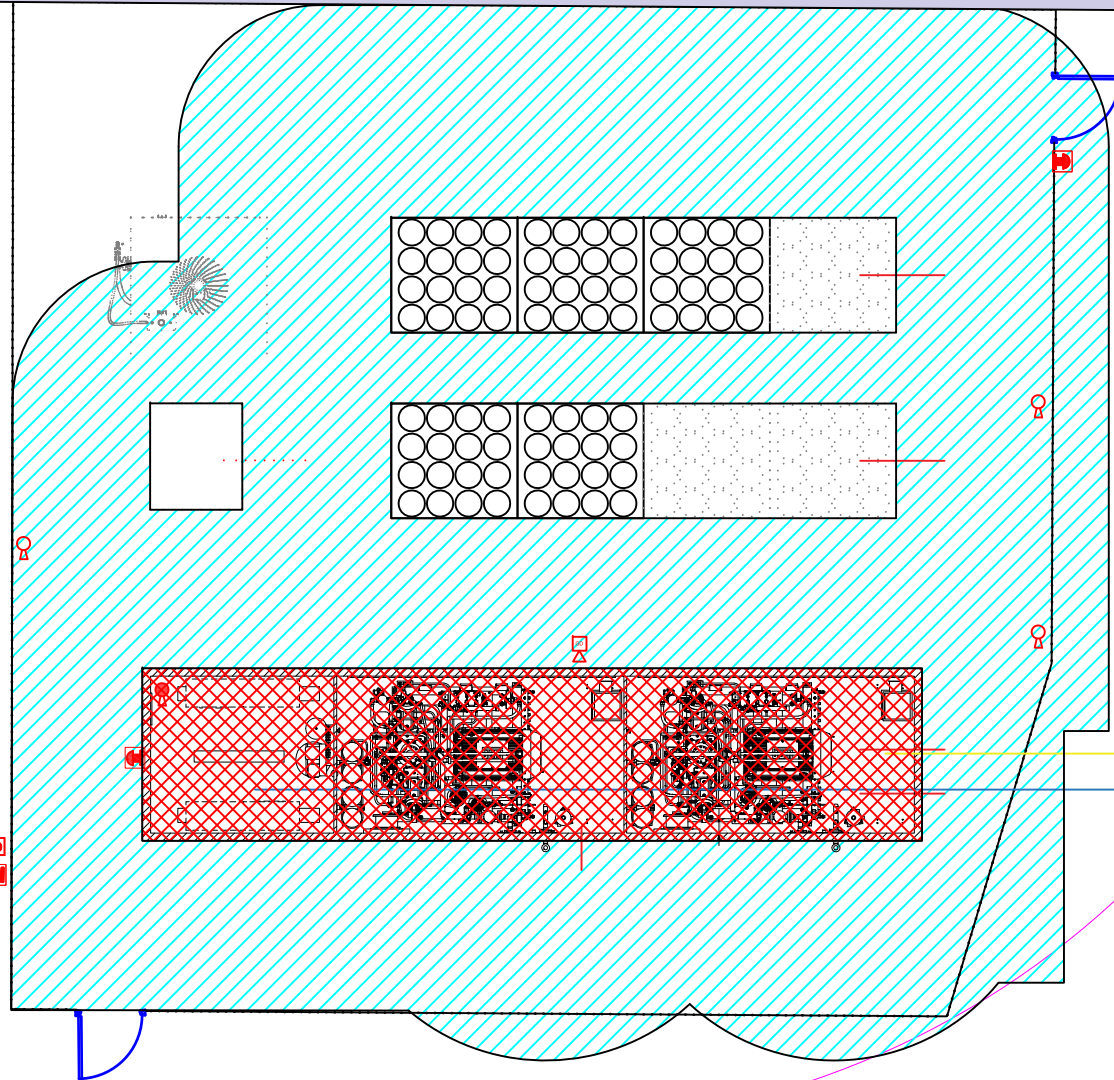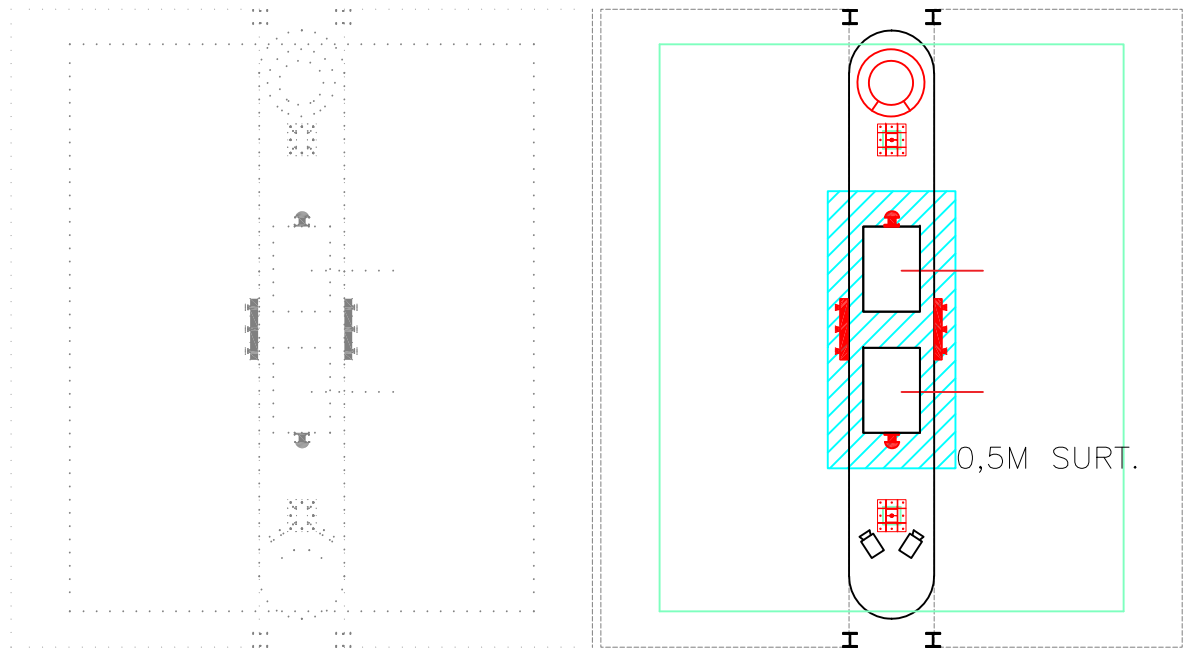

D					--	INTELLECTUAL PROPERTY: ALL RIGHTS RESERVED. DO NOT ALLOW THE USE OR THE TOTAL OR PARTIAL REPRODUCTION OF THIS DOCUMENT OR DISSEMINATION TO THIRD PARTIES WITHOUT PRIOR EXPRESS WRITTEN AUTHORIZATION.		REALIZED BY	CHECKED BY	APPROVED BY	APPROVED FOR CONSTRUCTION
C	ISLETA 2 "PUNTEADA"	29/07/22	C.F	R.C	--		NAME	--	--	--	--
B	MOD. DISPOSICIÓN EQUIPOS	27/07/22	C.F	R.C	--		DATE	--	--	--	--
A	FIRST EDITION	13/07/22	C.F	R.C	--		PROJECT AND TITLE OF DRAWING				
REV.	DESCRIPTION		DATE	REALIZED BY	CHECKED BY	APPROVED BY	31540001CP01 – ESTACIÓN GNC ZONAS DE SEGURIDAD				
CONTROL OF CHANGES											
 HAM CRIOGÉNICA,S.L. Pol.Ind. Sant Ermengol Parc. 11 08030 - ABRERA (Barcelona) www.ham.es T: +34 93 770 47 60		CUSTOMER MANCOMUNIDAD DE PAMPLONA		FORMAT A2	SCALE S.E		PLANE NUMBER DWG_6_SEGURIDAD			SHEET 1 of 1	REVIEW C

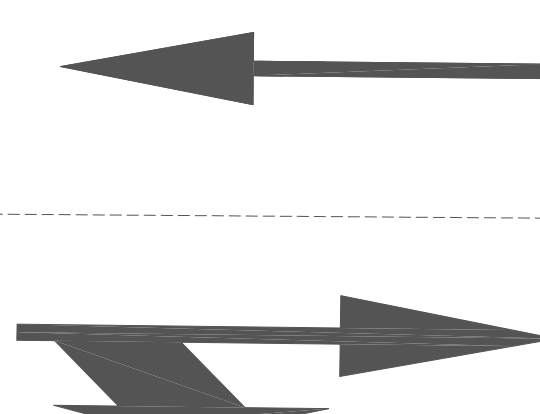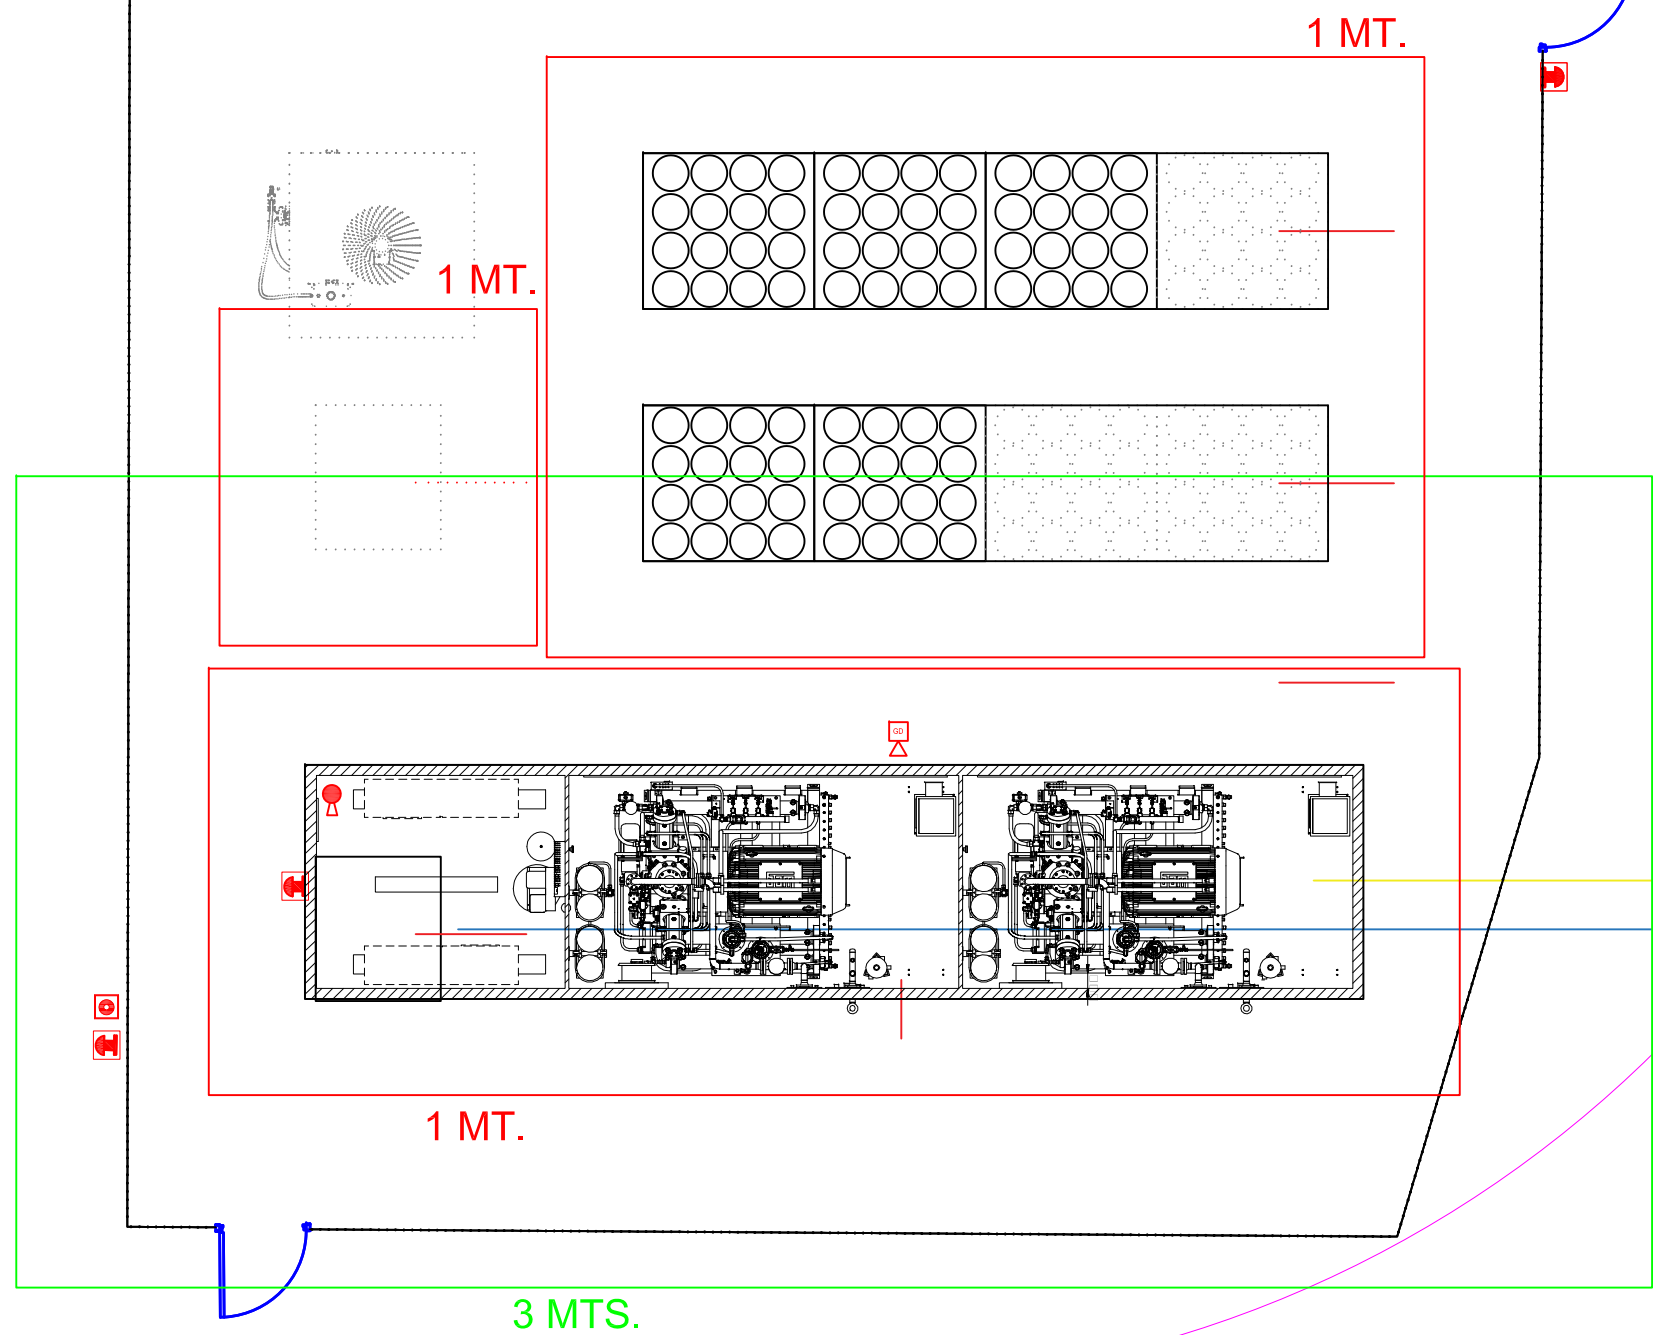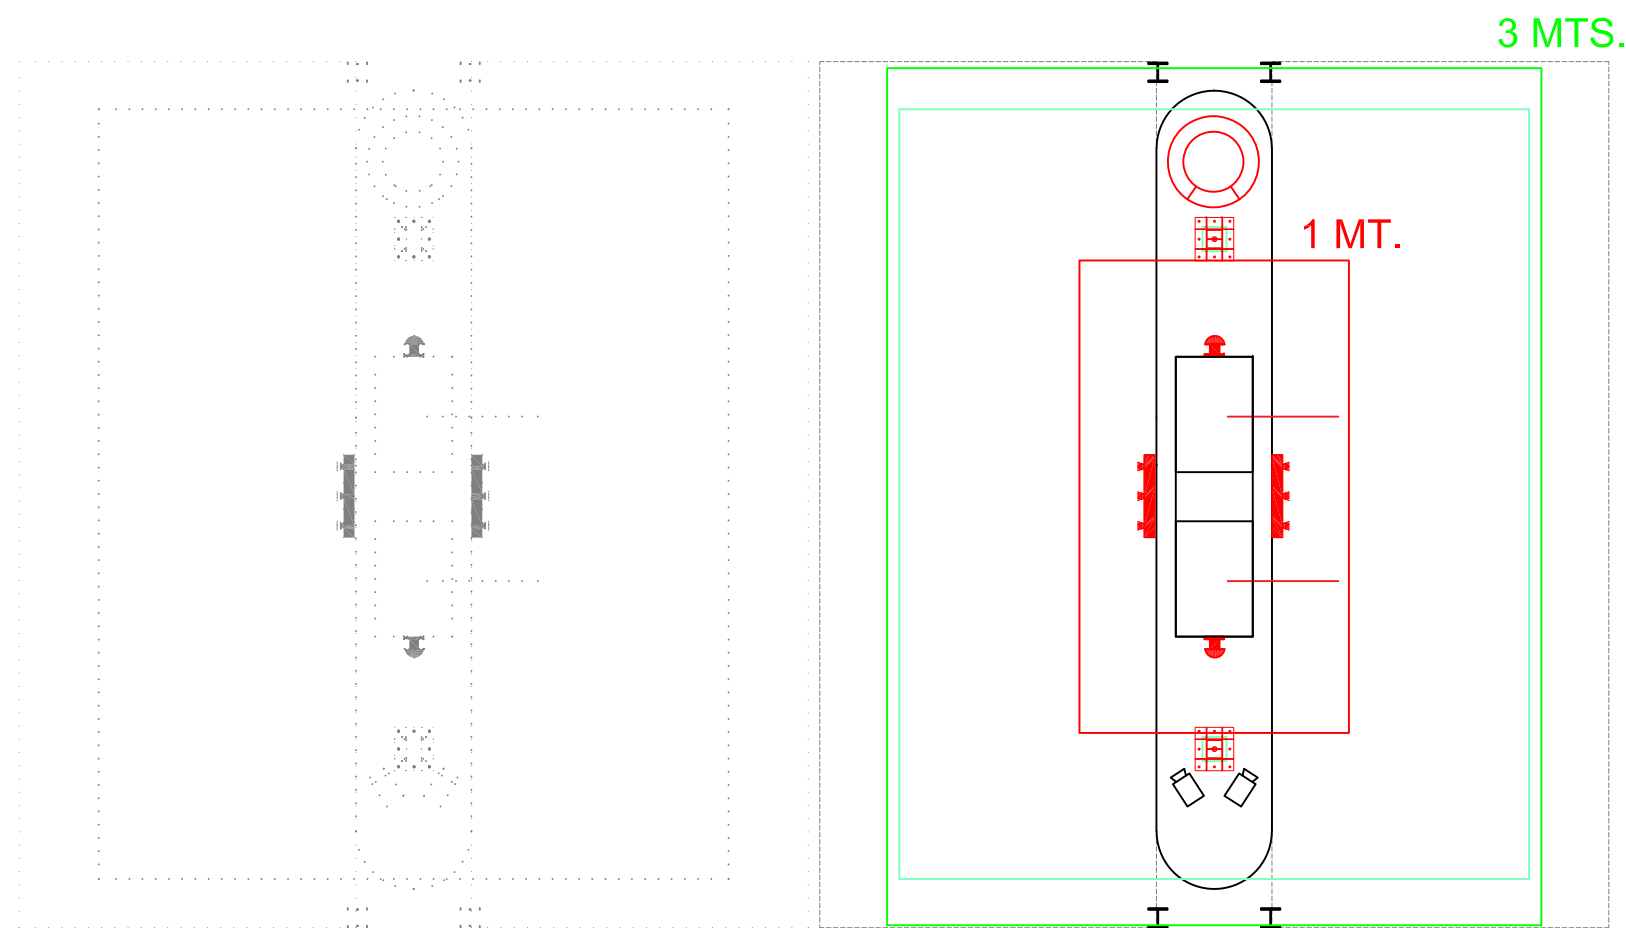


D					--	INTELLECTUAL PROPERTY: ALL RIGHTS RESERVED. DO NOT ALLOW THE USE OR THE TOTAL OR PARTIAL REPRODUCTION OF THIS DOCUMENT OR DISSEMINATION TO THIRD PARTIES WITHOUT PRIOR EXPRESS WRITTEN AUTHORIZATION.	REALIZED BY	CHECKED BY	APPROVED BY	APPROVED FOR CONSTRUCTION
C					--		NAME	--	--	--
B	DISPOSICION EQUIPOS	27/07/22	C.F	R.C	--		DATE	--	--	--
A	FIRST EDITION	13/07/22	C.F	R.C	--	PROJECT AND TITLE OF DRAWING				
REV.	DESCRIPTION	DATE	REALIZED BY	CHECKED BY	APPROVED BY	31540001CP01 – ESTACIÓN GNC DISTANCIAS DE SEGURIDAD				
CONTROL OF CHANGES										
HAM CRIOGÉNICA,S.L. Pol. Ind. Sant Ermengol Parc. 11 08530 - ABRERA (Barcelona) www.ham.es T: +34 93 770 47 60		CUSTOMER MANCOMUNIDAD DE PAMPLONA		FORMAT A2	SCALE S.E			PLANE NUMBER DWG_7_DISTANCIAS	SHEET 1 OF 1	REVIEW B

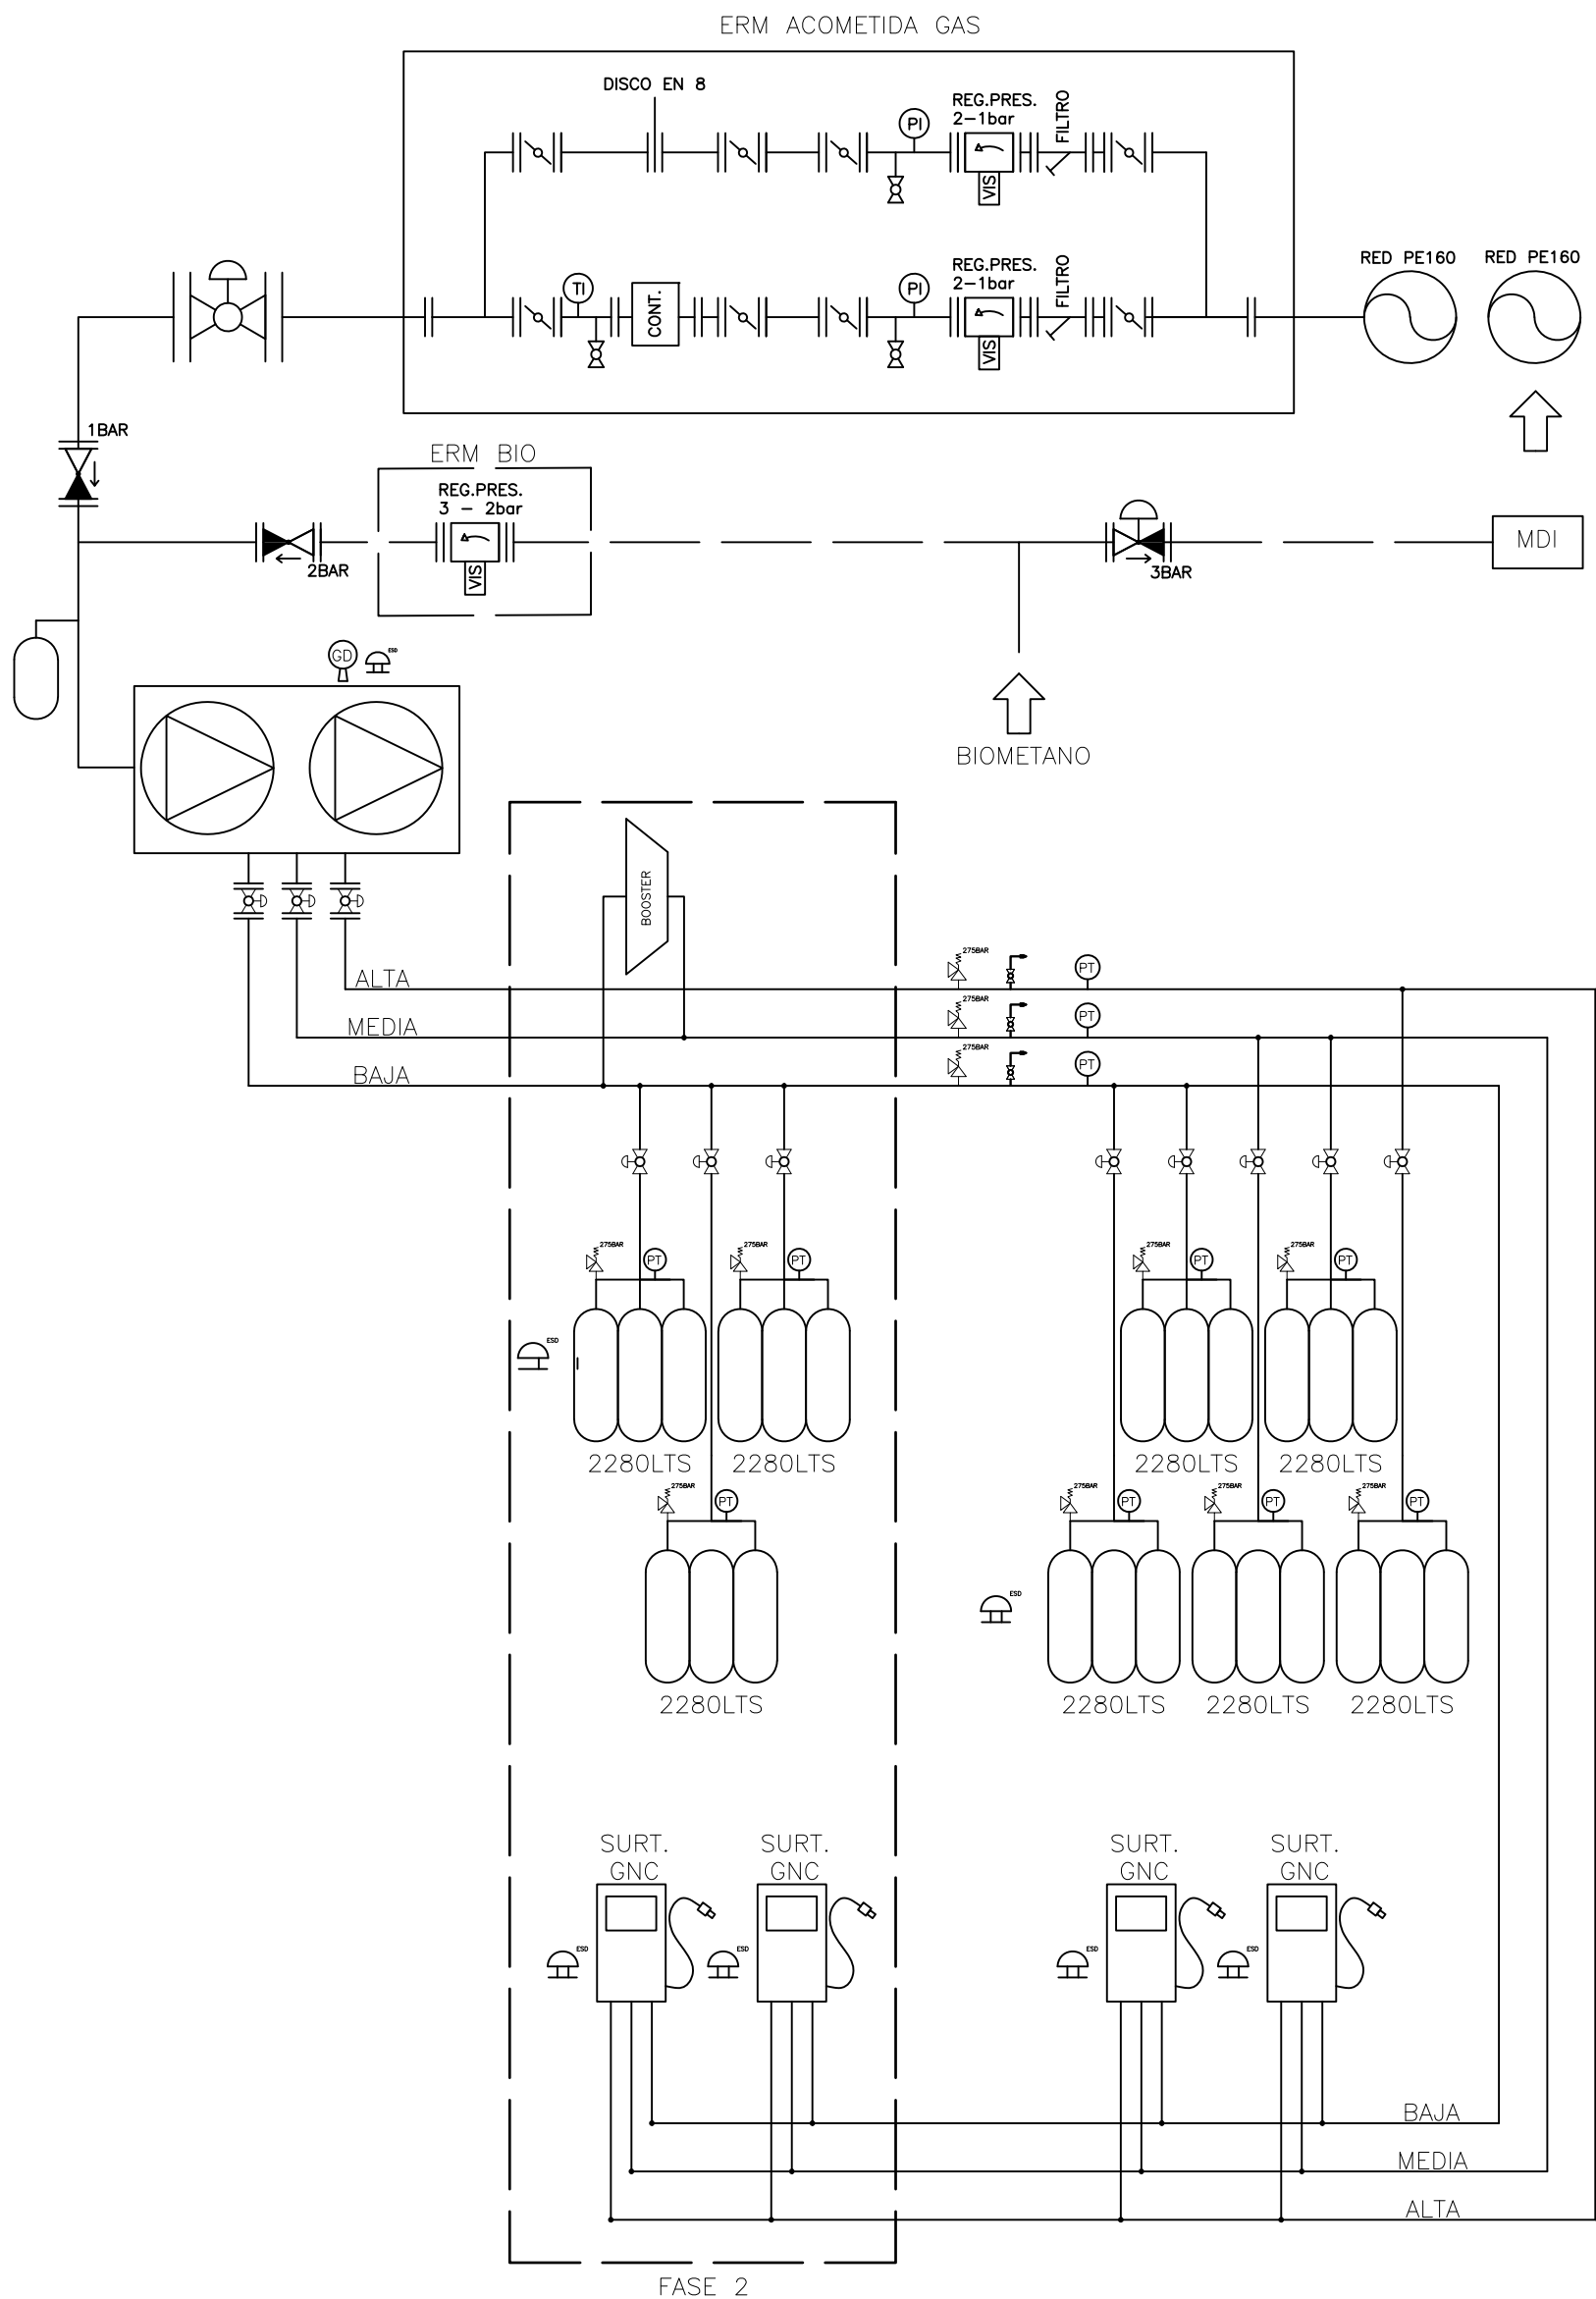


D					--	INTELLECTUAL PROPERTY: ALL RIGHTS RESERVED. DO NOT ALLOW THE USE OR THE TOTAL OR PARTIAL REPRODUCTION OF THIS DOCUMENT OR DISSEMINATION TO THIRD PARTIES WITHOUT PRIOR EXPRESS WRITTEN AUTHORIZATION.		REALIZED BY	CHECKED BY	APPROVED BY	APPROVED FOR CONSTRUCTION
C					--		NAME	-	-	-	-
B					--		DATE	-	-	-	-
A	FIRST EDITION	14/07/22	C.F	R.C	--	PROJECT AND TITLE OF DRAWING					
REV.	DESCRIPTION	DATE	REALIZED BY	CHECKED BY	APPROVED BY	31540001CP01 - ESTACIÓN GNC CIRCUITO DE GAS					
CONTROL OF CHANGES											
HAM CRIOGÉNICA,S.L. Pol. Ind. Sant Ermengol, Parc. 11 08630 - ABRERA (Barcelona) www.ham.es T: +34 93 770 47 60		CUSTOMER MANCOMUNIDAD DE PAMPLONA		FORMAT A2	SCALE n/a	PLANE NUMBER PID_1		SHEET 1 OF 1		REVIEW A	

CUADRO GENERAL CNC

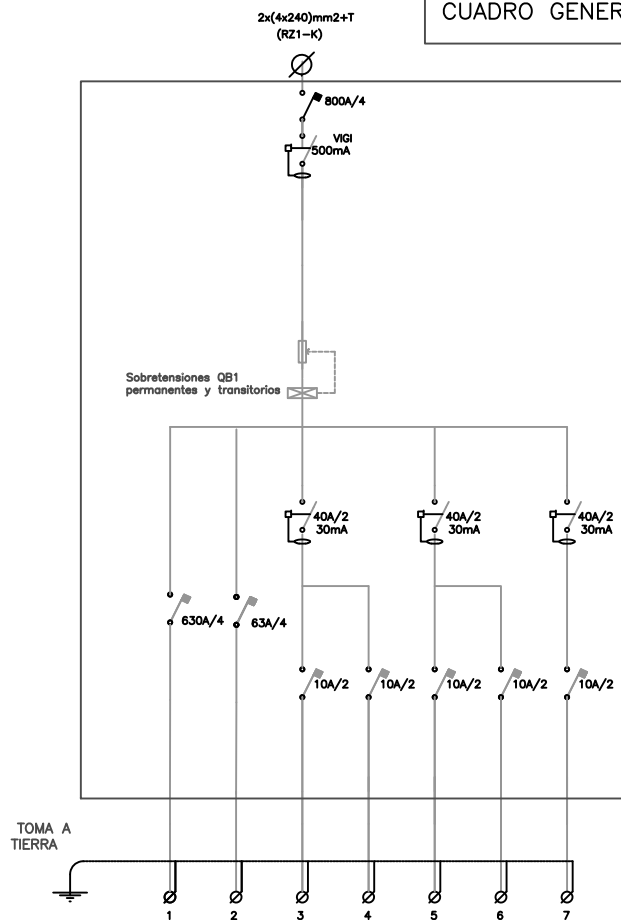


CIRCUITO	SUBCUADRO COMPRESOR GNC	SUBCUADRO BOOSTER	SURTIDOR 1	SURTIDOR 2	ILUMINACIÓN	LECTORES DE MATRÍCULA	ERM
ORDEN	—	—	—	—	—	—	—
POTENCIA (W)	500.000	40.500	600	600	500	800	1.200
SECCIÓN	4X480+T	4X25+T	2X6+T	2X6+T	2X6+T	2X6+T	2X6+T
LONGITUD	25	25	20	30	30	25	30

SUBCUADRO COMPRESORES

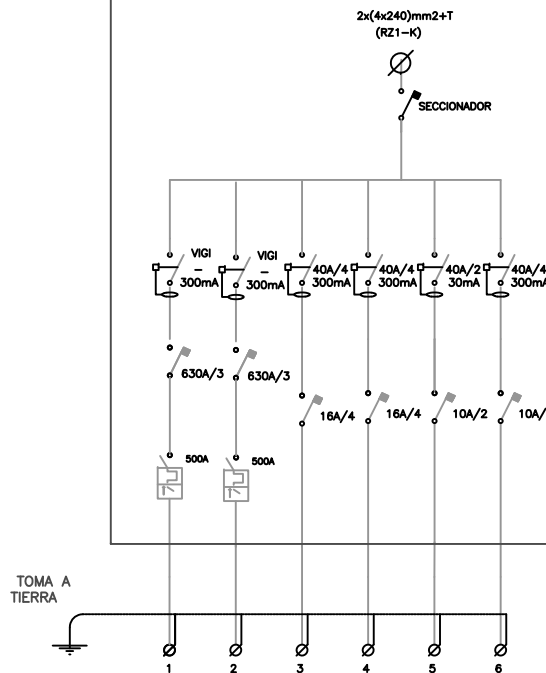



CIRCUITO	COMPRESOR GNC 1	COMPRESOR GNC 2	COMPRESOR AIRE	VENTILADOR INTERC.	ILUMINACIÓN	BOMBA AGUA
ORDEN	—	—	—	—	—	—
POTENCIA (W)	250.000	250.000	2.200	1.900	250	500
SECCIÓN	4X240+T	4X240+T	4X1,5+T	4X25+T	4X1,5+T	4X2,5+T
LONGITUD	5	10	10	5	10	10

SUBCUADRO BOOSTER

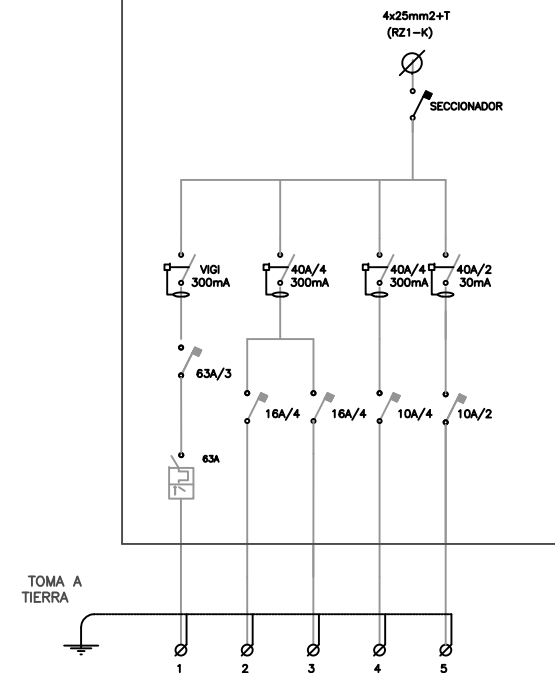


CIRCUITO	BOOSTER BOMBA HIDRAULICA	VENTILADOR AIRE 1	VENTILADOR AIRE 2	BOMBA AGUA BOOSTER	AUTOMATA BOOSTER
ORDEN	—	—	—	—	—
POTENCIA (W)	30.000	4.500	4.500	1.000	500
SECCIÓN	4X16+T	4X4+T	4X4+T	4X2,5+T	2X2,5+T
LONGITUD	5	10	10	10	5


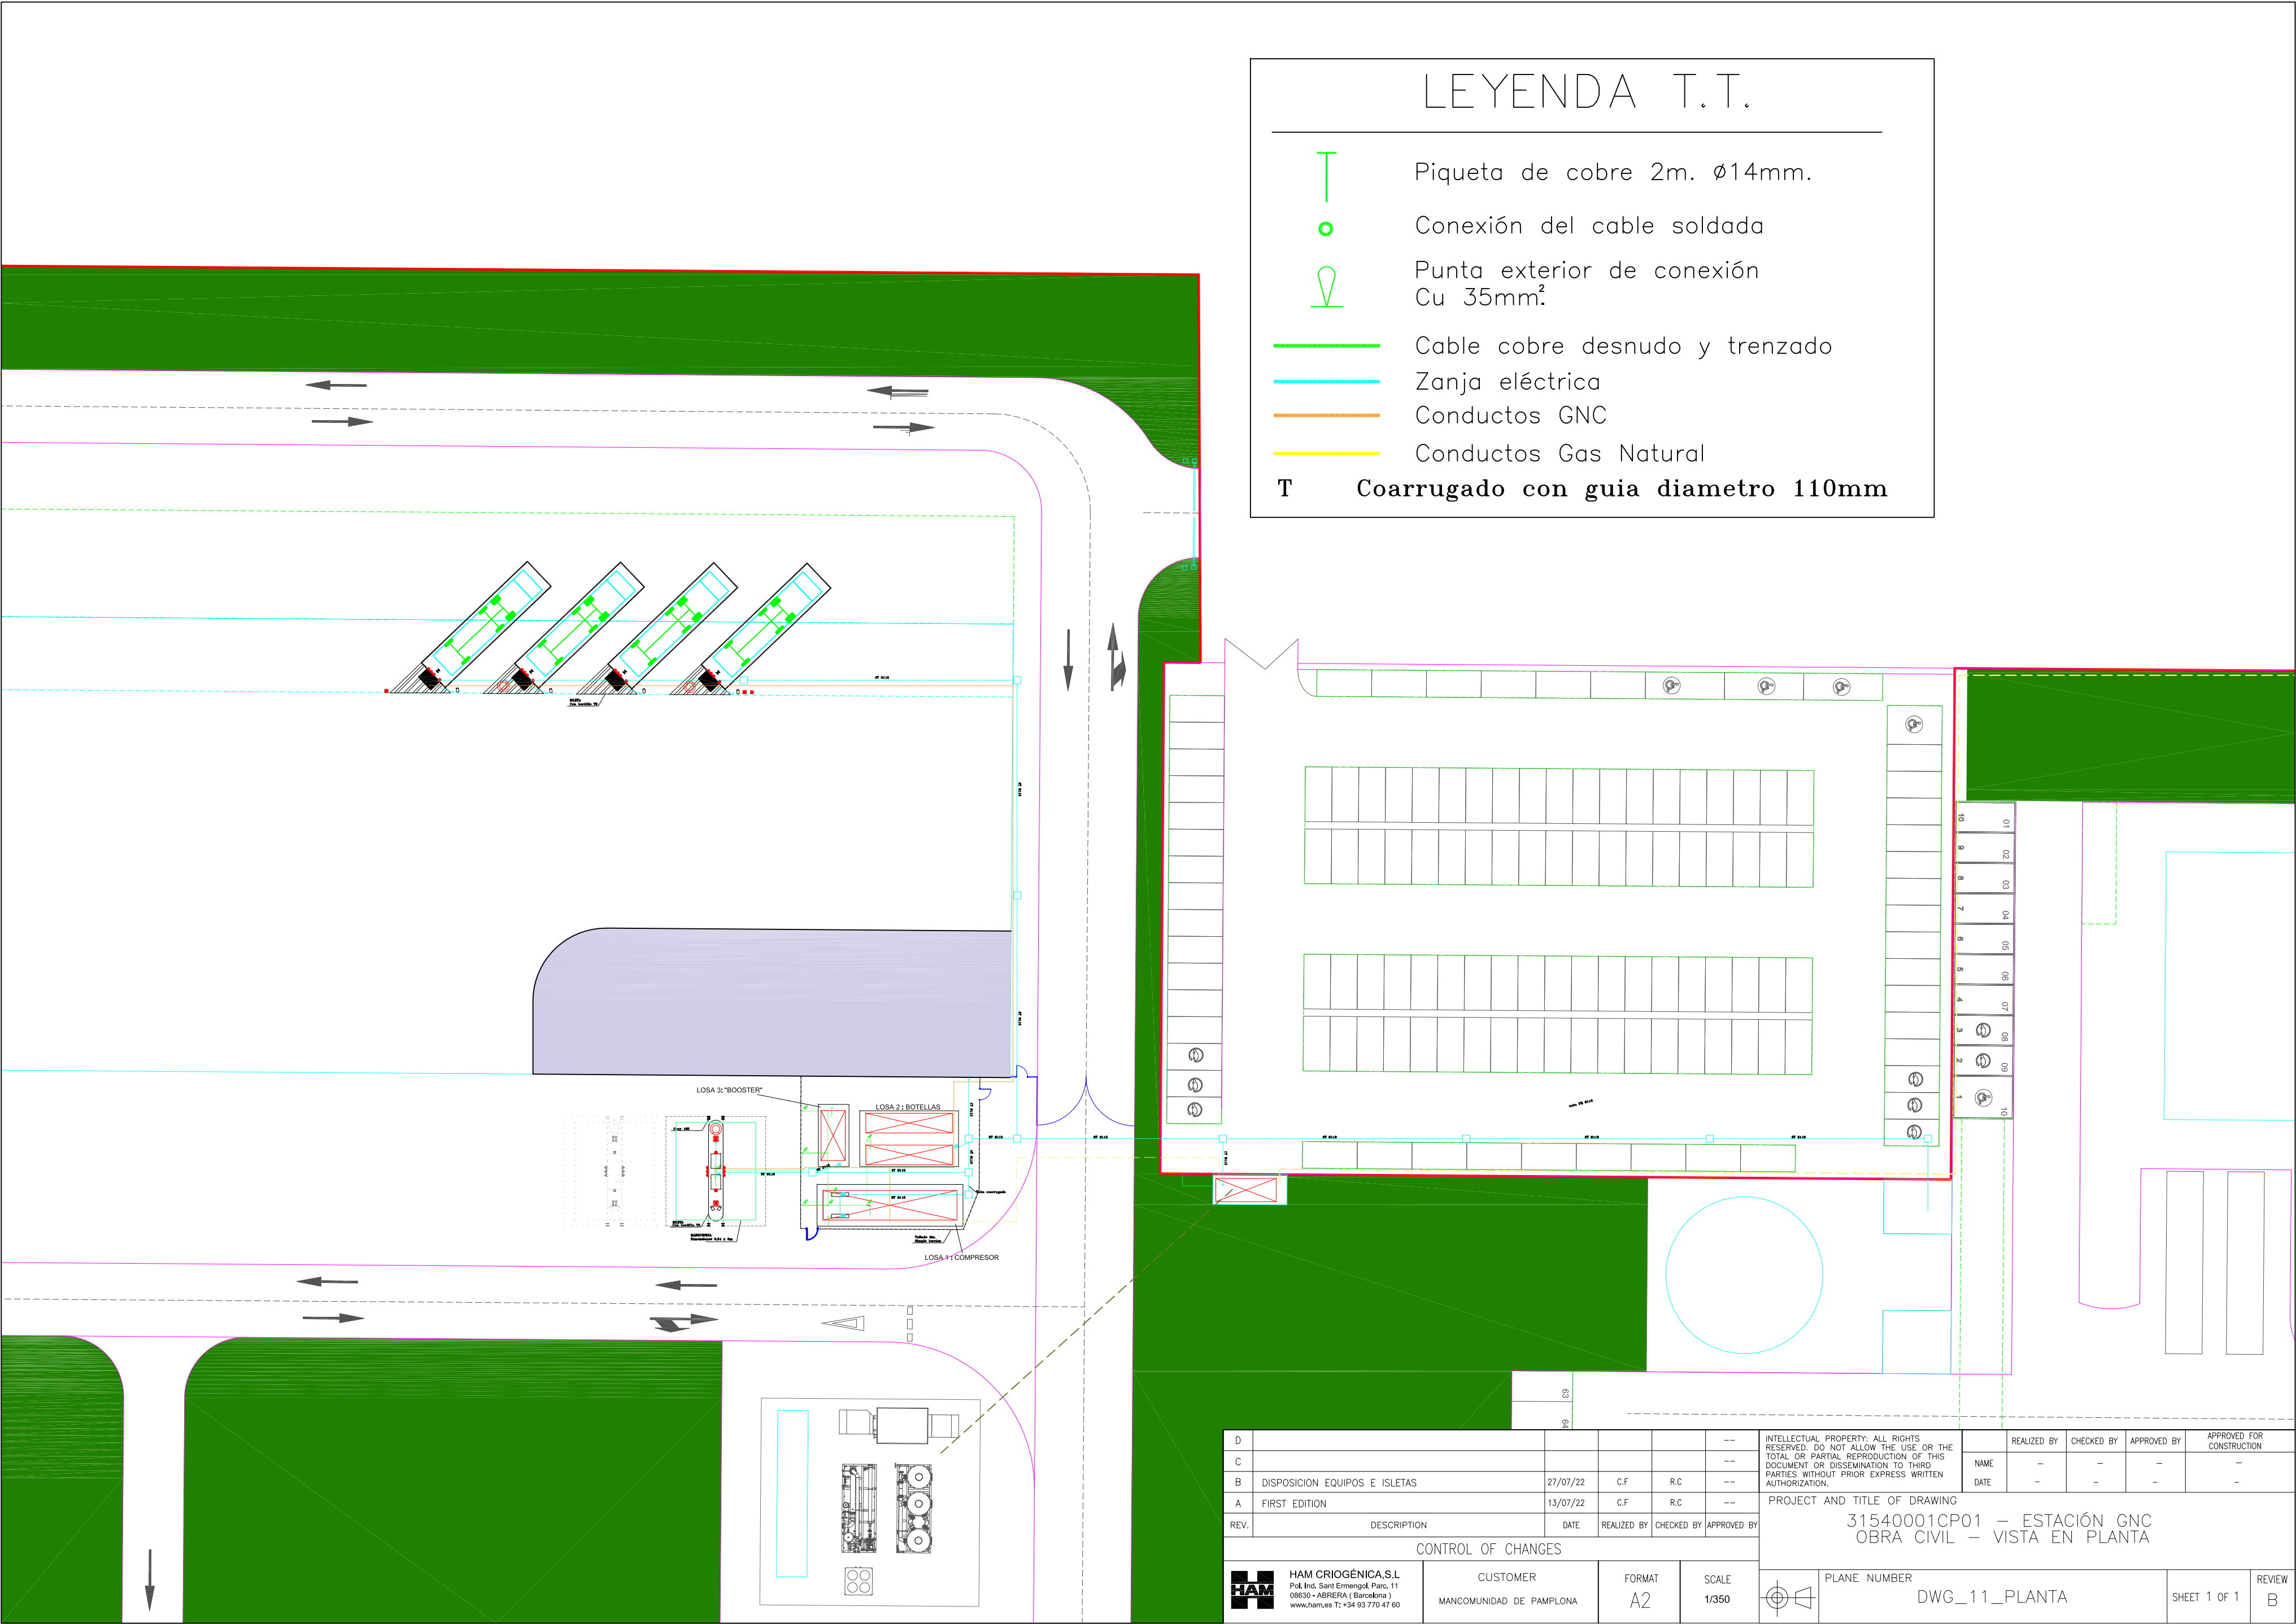


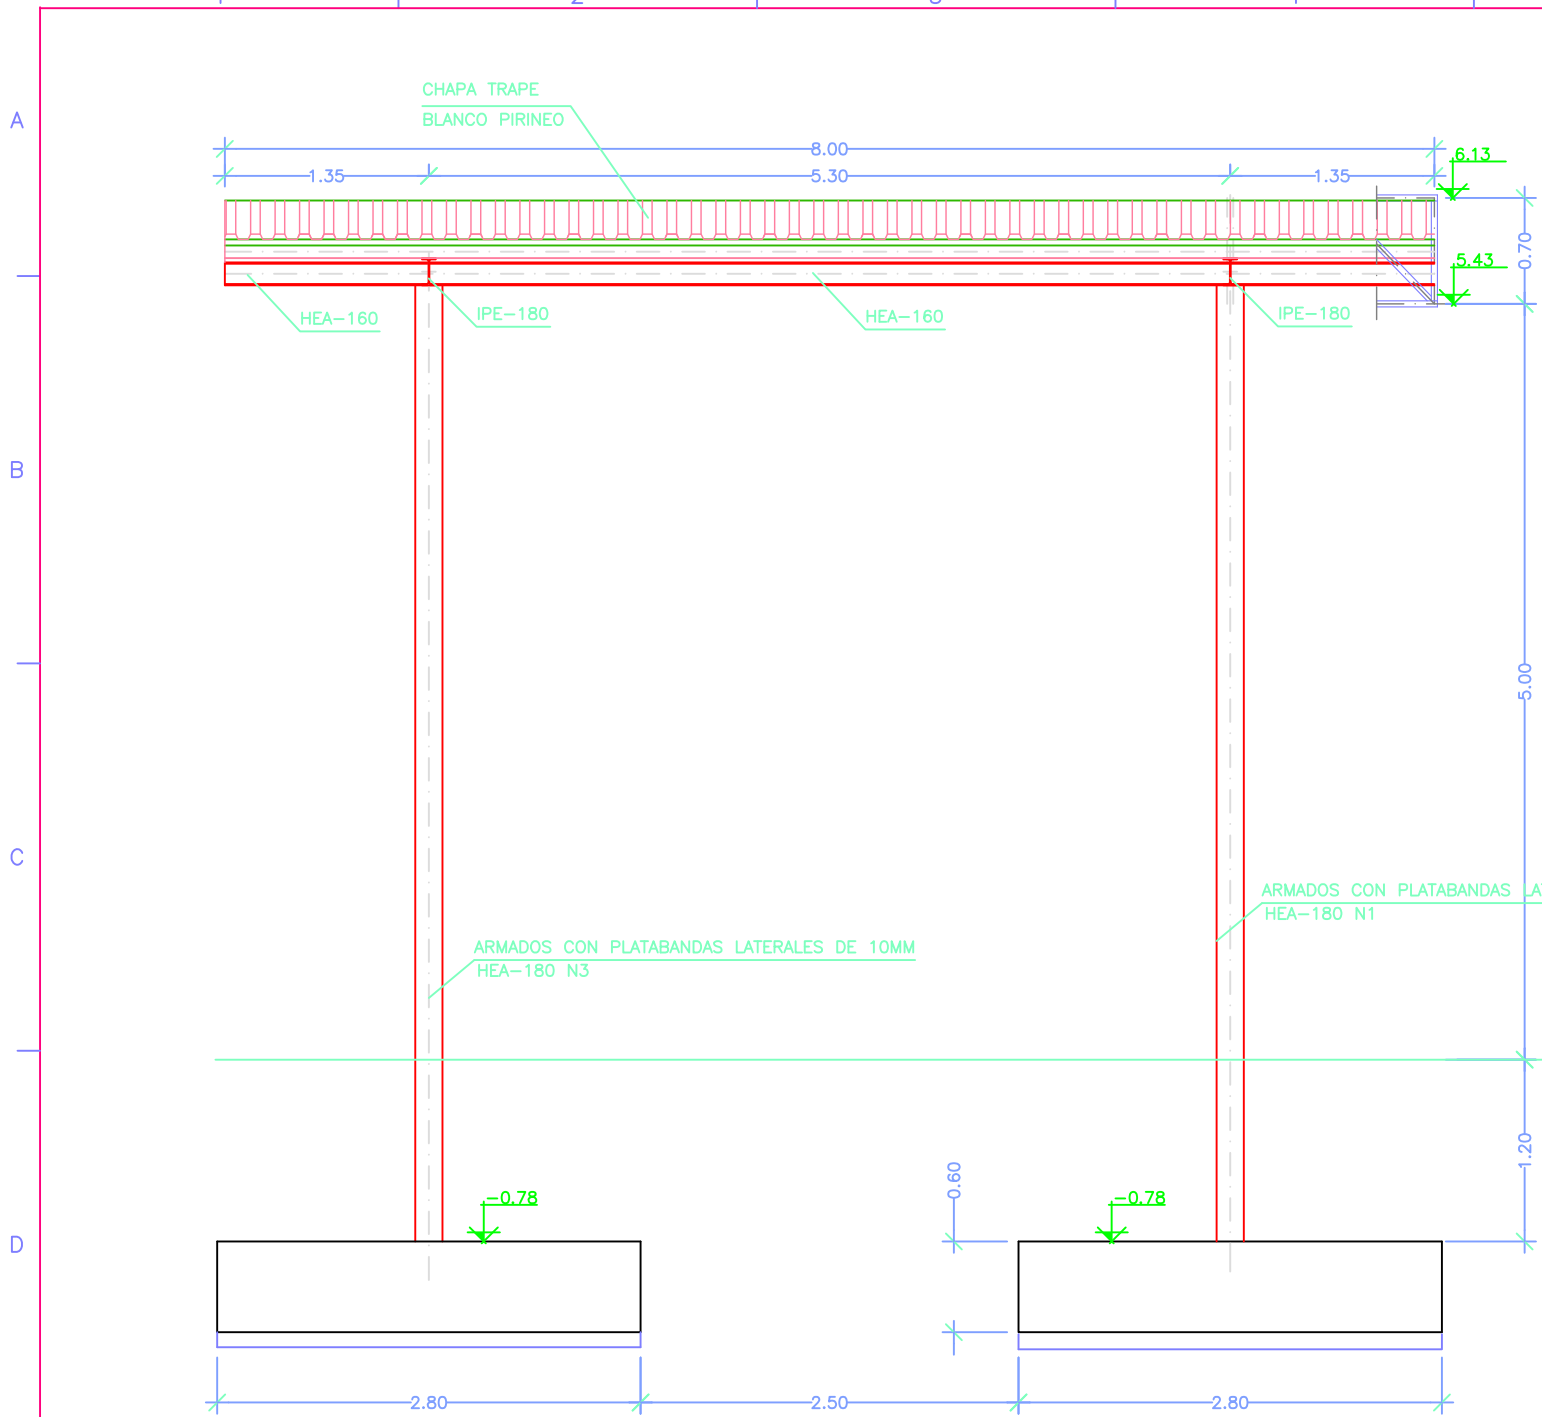


PORTICO 1
ESCALA 1/50

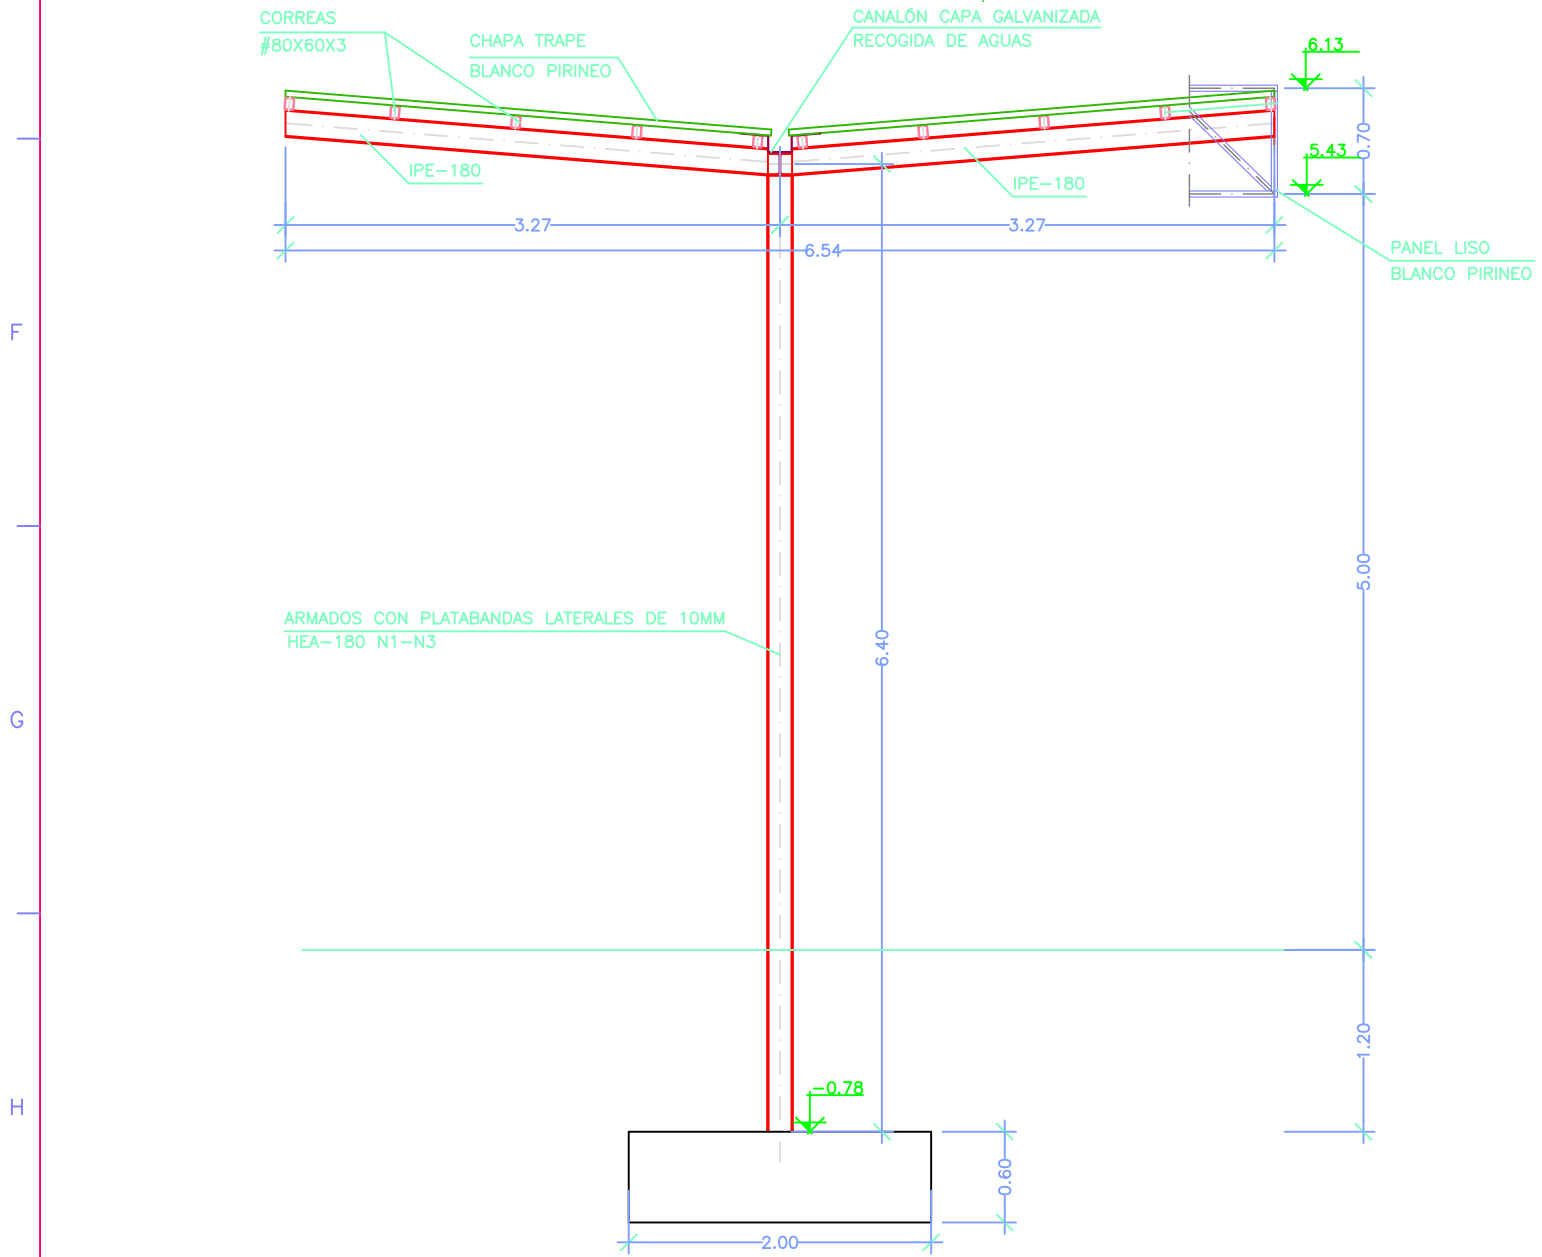


PORTICO 2 Y 3
ESCALA 1/50

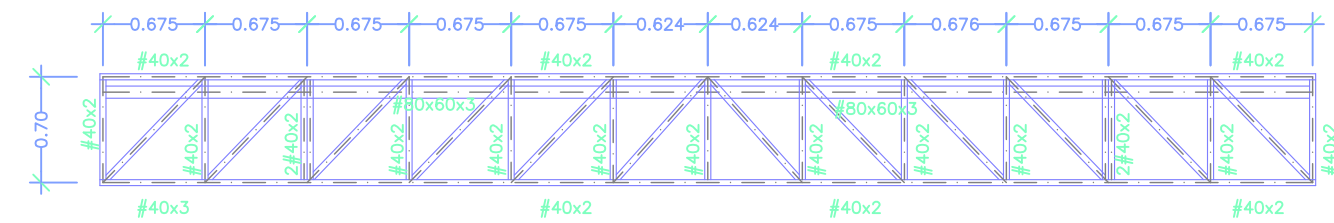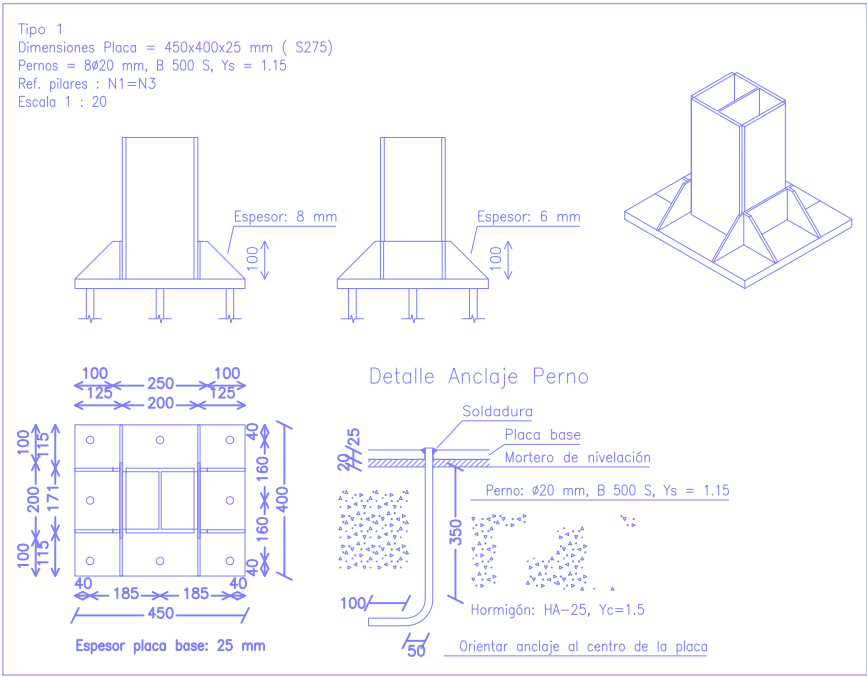

CERCHA 1 Y 3
ESCALA 1/50

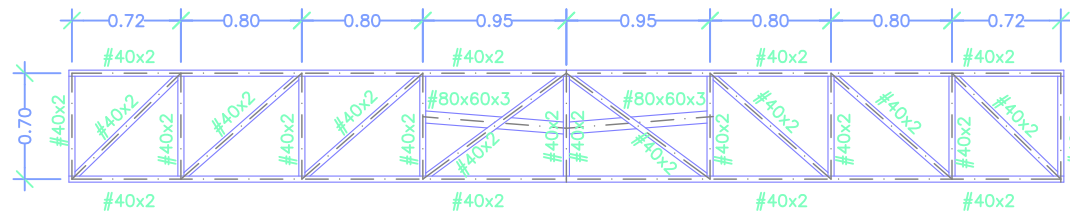


CERCHA 2 Y 4
ESCALA 1/50

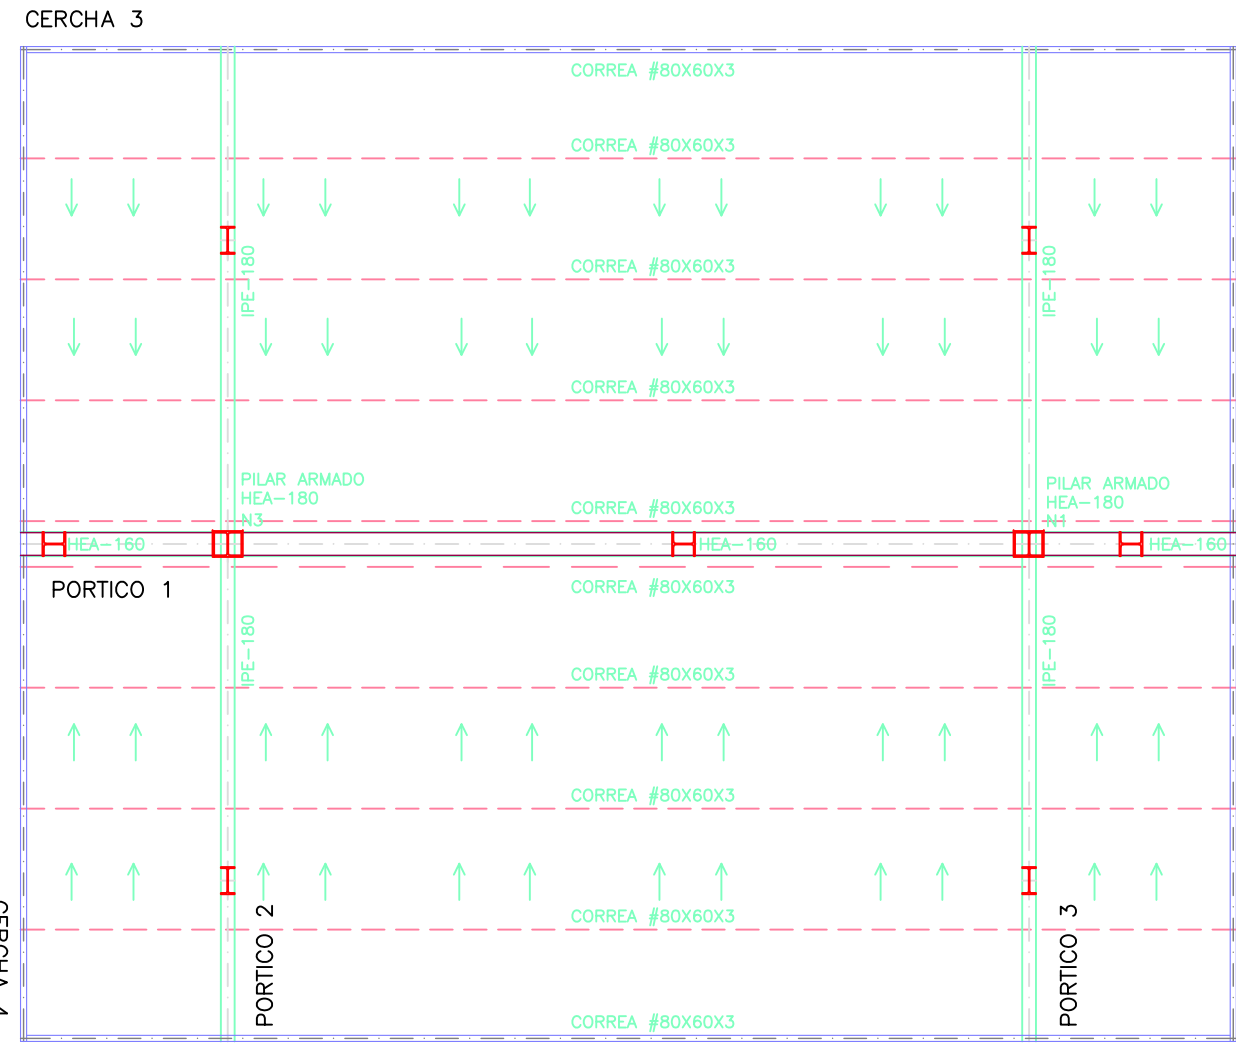

CERCHA 1

CUBIERTA MARQUESINA 1 Y 2
ESCALA 1/50

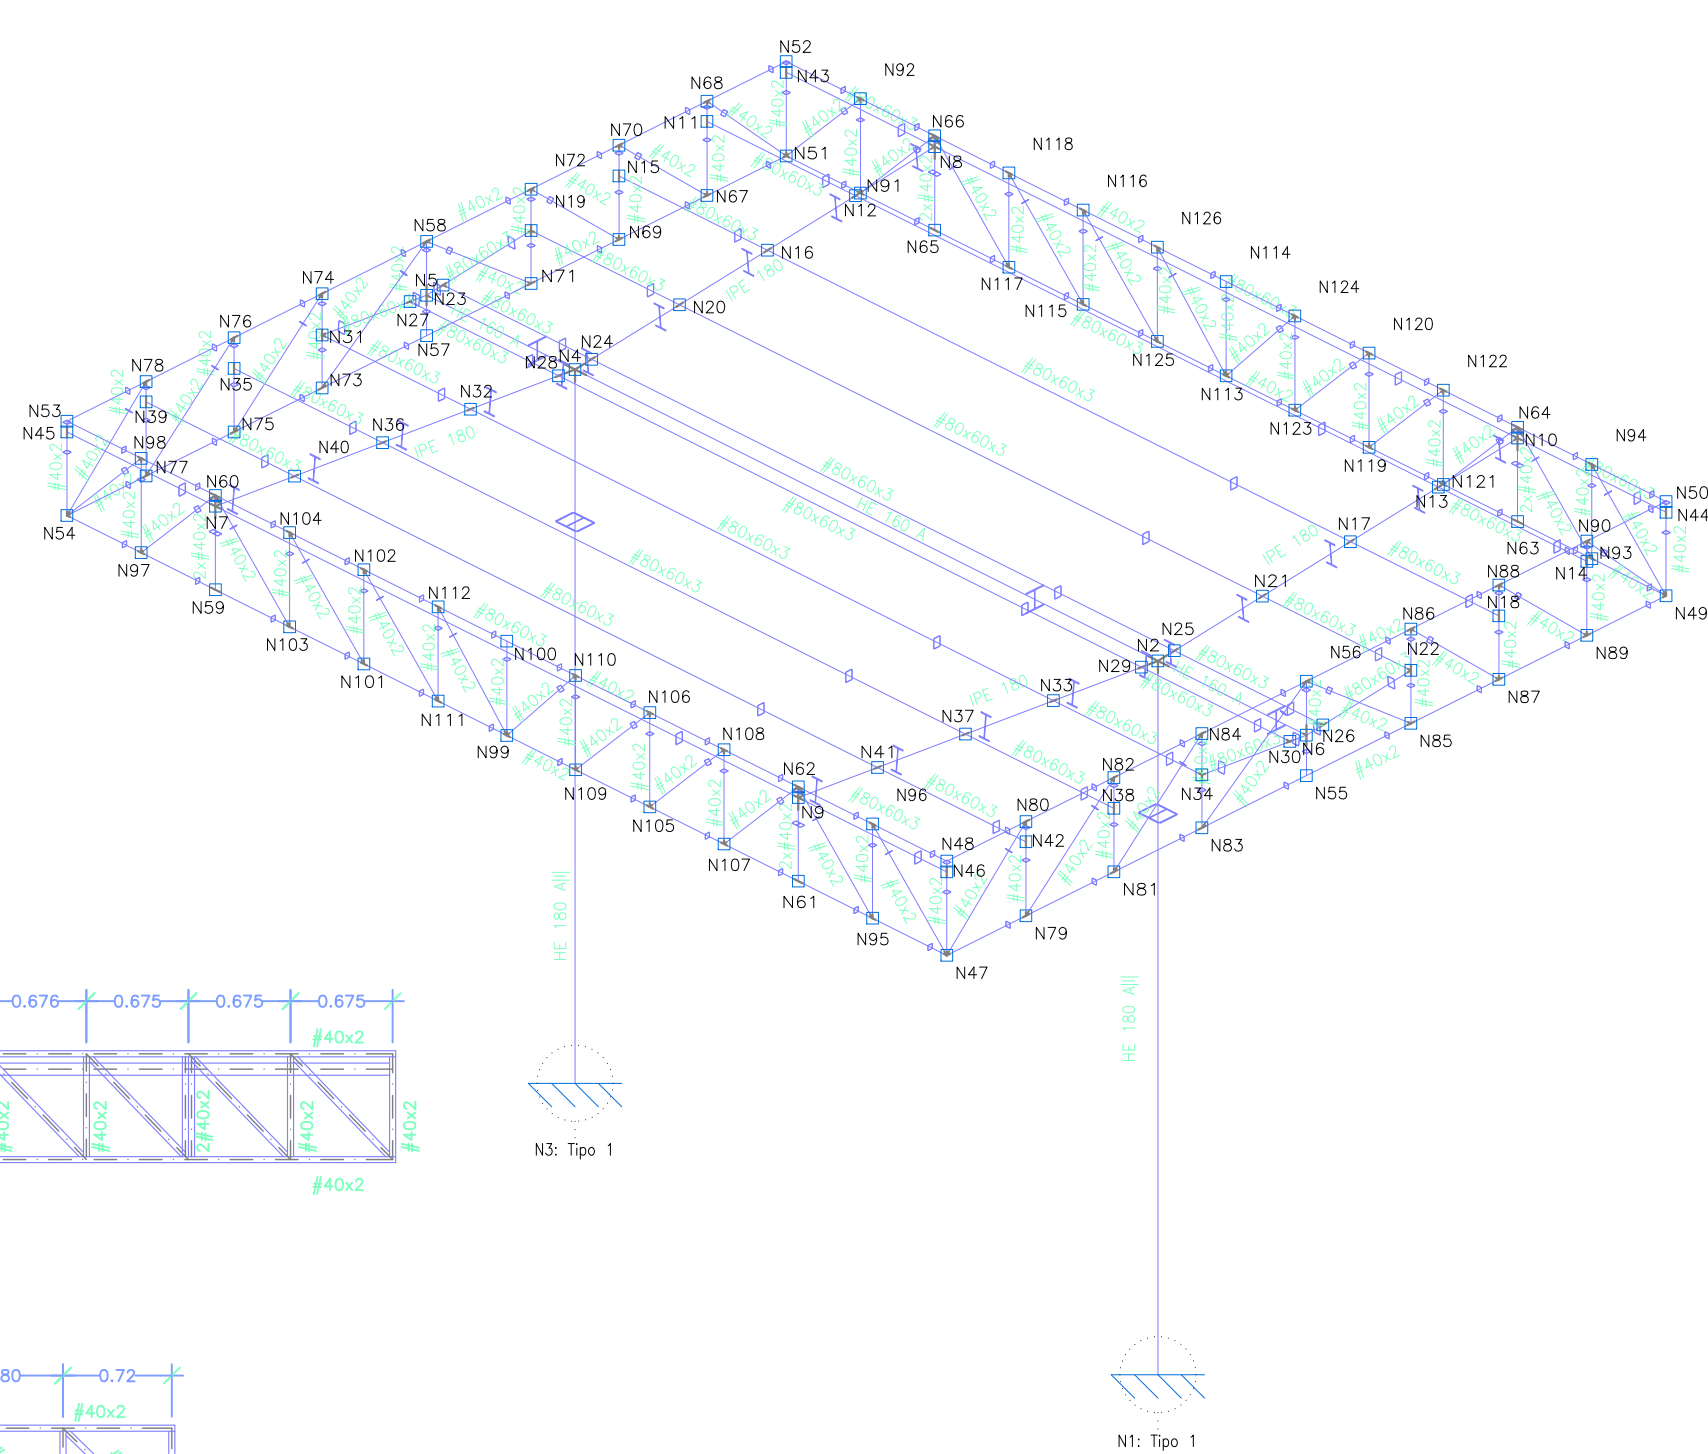

LOSA CIMENTACIÓN
ESCALA 1/100

Resumen Acero	Long. total (m)	Peso+10% (kg)
B 500 S, Ys=1.15	214,4	209

Referencias	Pernos de Placas de Anclaje	Dimensión de Placas de Anclaje
N3 y N1	8 Pernos ø 20	Placa base (450x400x25)

Referencias	Pernos de Placas de Anclaje	Dimensión de Placas de Anclaje
N3 y N1	8 Pernos ø 20	Placa base (450x400x25)

Elemento	Pos.	Diám.	No.	Long. (cm)	Total (cm)	B 500 S, Ys=1.15 (kg)
N3=N1	1	ø12	10	270	2700	24,0
	2	ø12	14	190	2660	23,6
	3	ø12	10	270	2700	24,0
	4	ø12	14	190	2660	23,6
Total+10% (v2):						104,7
ø12: Total:						209,4

PLANTA GENERAL
ESCALA 1/300

NOTA:
ENCUENTRO ENTRE PÓRTICOS
1 CON 2 Y 3
SOLDADURAS CON PREPARACIÓN
DE BORDES A BISEL,
PARA ASEGURAR
LA SOLDADURA CONTÍNUA.

HAM CRIOCÉNICA S.L.
Pol. Ind. Sant Emmergall, Para. 11
08630 - ABRERA (Barcelona)
www.ham.es T: +34 93 770 47 60

 
MARQUESINA
ESTACIÓN SERVICIO GAS
NATURAL VEHICULAR GNC

PLANO : MARQUESINA
Nº DE PLANO : E-02
ORIGINAL A-2

PETICIONARIO : MANCOMUNIDAD PAMPLONA
ESCALA : INDICADAS

SITUACIÓN : CACP PAMPLONA
REF: 07/22
FEDAL: JULIO 2022

LEYENDA T.T.




Piqueta de cobre 2m. Ø14mm.




Conexión del cable soldada



 Punta exterior de conexión
Cu 35mm²




Cable cobre desnudo y trenzado

 

Zanja eléctrica



 
Conductos GNC




Conductos Gas Natural



Coarrugado con guía diametro 110mm

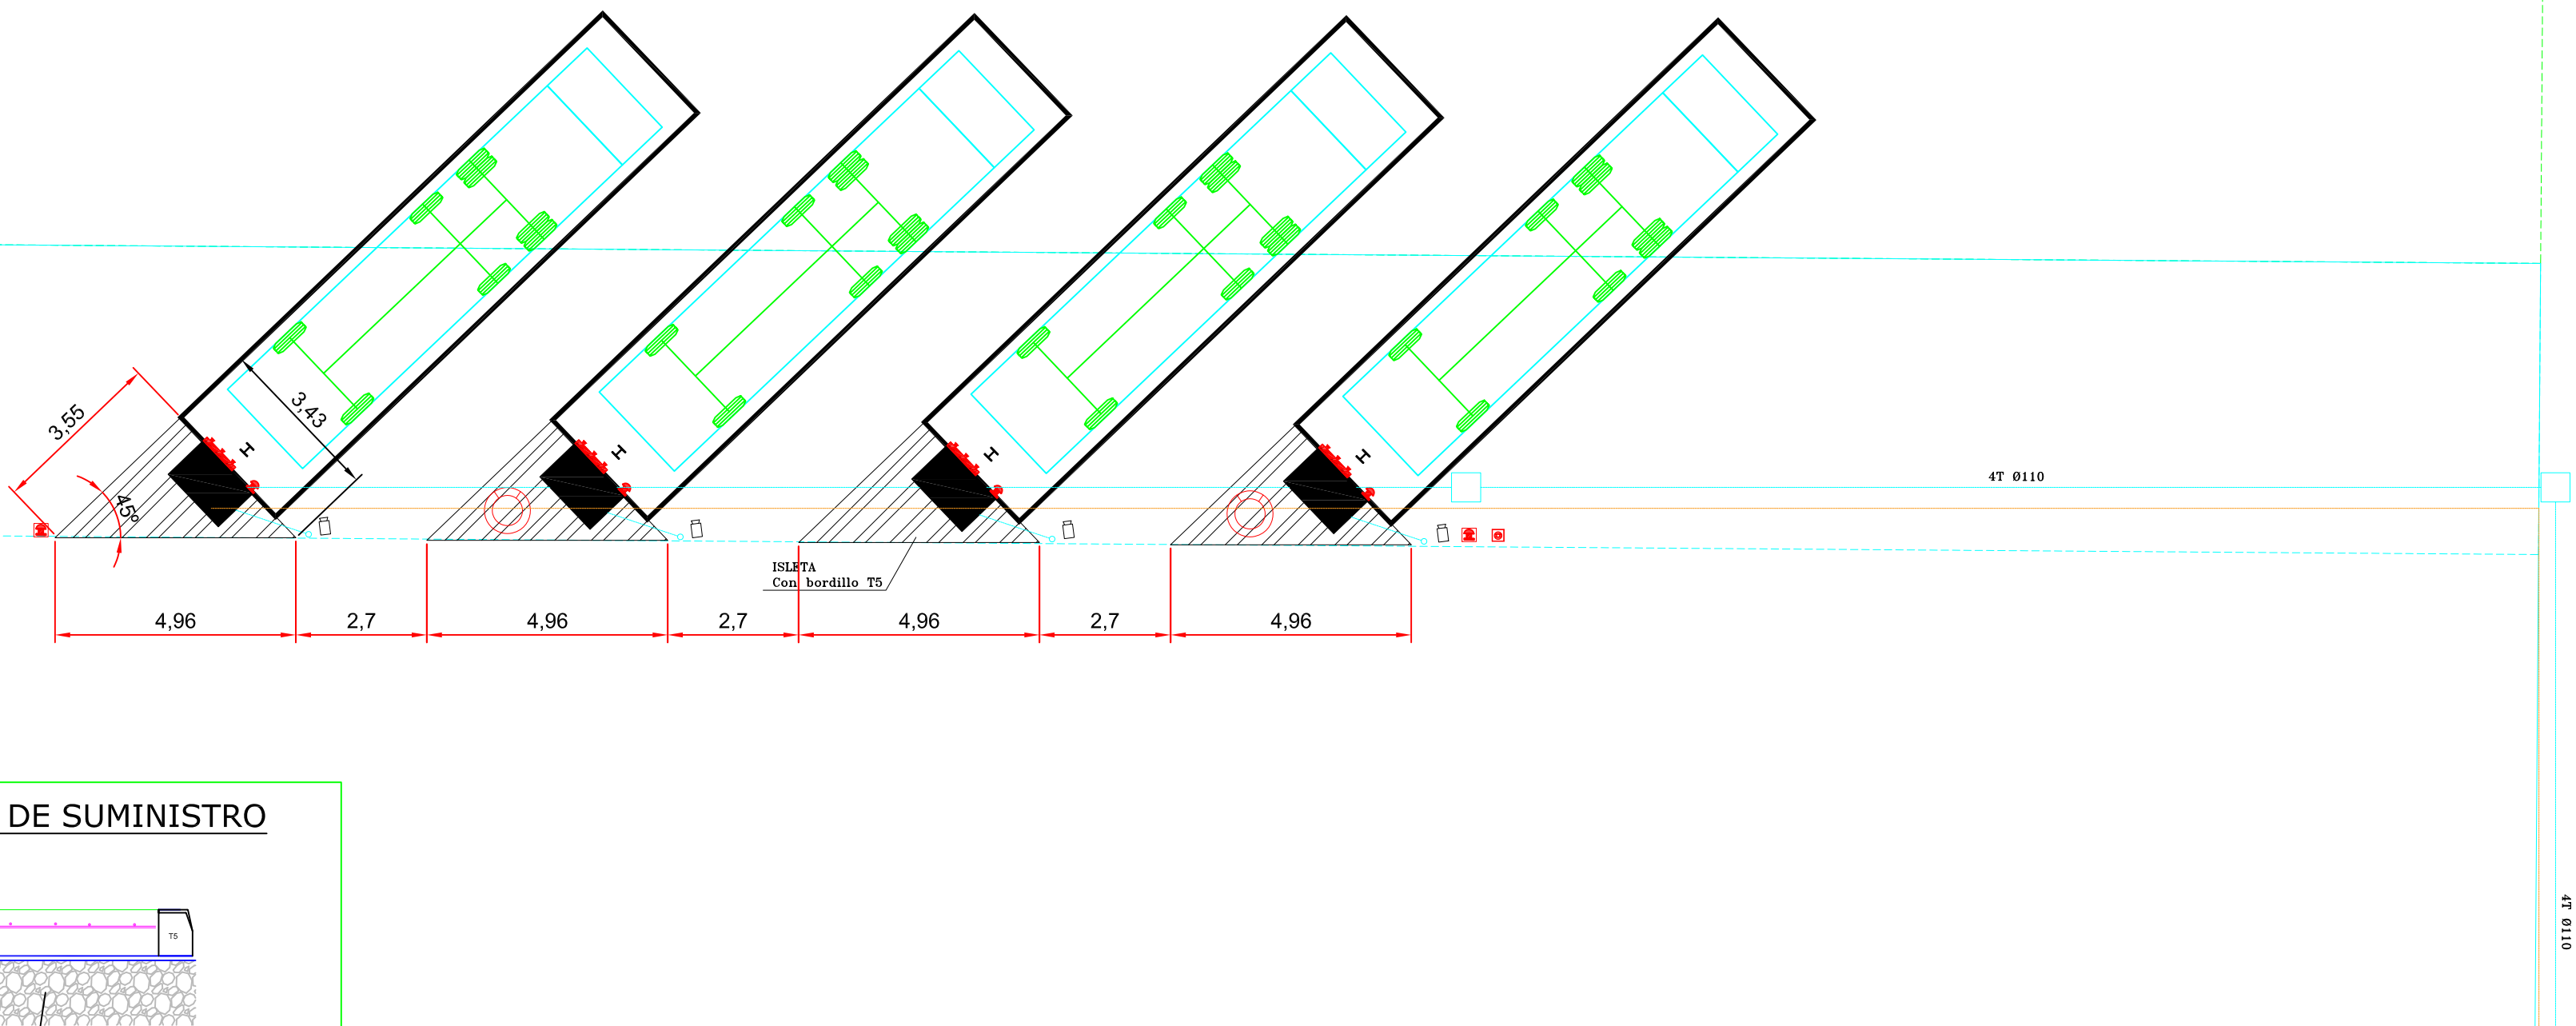


SECCIÓN ISLETA DE SUMINISTRO

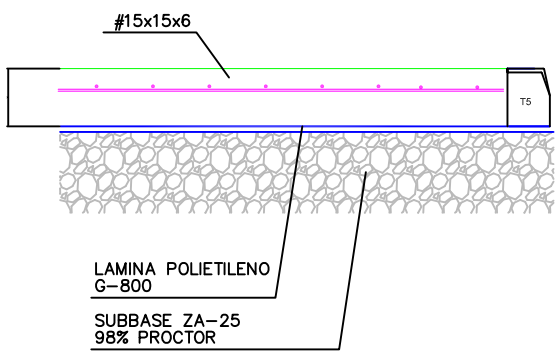

NOTA: VERIFICAR DIMENSIONES ARQUETA SURTIDOR

D					--	INTELLECTUAL PROPERTY: ALL RIGHTS RESERVED. DO NOT ALLOW THE USE OR THE TOTAL OR PARTIAL REPRODUCTION OF THIS DOCUMENT OR DISSEMINATION TO THIRD PARTIES WITHOUT PRIOR EXPRESS WRITTEN AUTHORIZATION.		REALIZED BY	CHECKED BY	APPROVED BY	APPROVED FOR CONSTRUCTION	
C					--		NAME	-	-	-	-	
B					--		DATE	-	-	-	-	
A	FIRST EDITION	13/07/22	C.F	R.C	--	PROJECT AND TITLE OF DRAWING						
REV.	DESCRIPTION		DATE	REALIZED BY	CHECKED BY	APPROVED BY	31540001CP01 – ESTACIÓN GNC O.C ZONA DE SUMINISTRO (FASE 2)					
CONTROL OF CHANGES												
	HAM CRIOGÉNICA,S.L Pol.Ind. Sant Ermengol Parc. 11 08030 - ASERVA (Barcelona) www.ham.es T: +34 93 770 47 60		CUSTOMER MANCOMUNIDAD DE PAMPLONA		FORMAT A2	SCALE S.E		PLANE NUMBER			SHEET 1 of 1	REVIEW A
								DWG_4_OC SUMINISTRO				

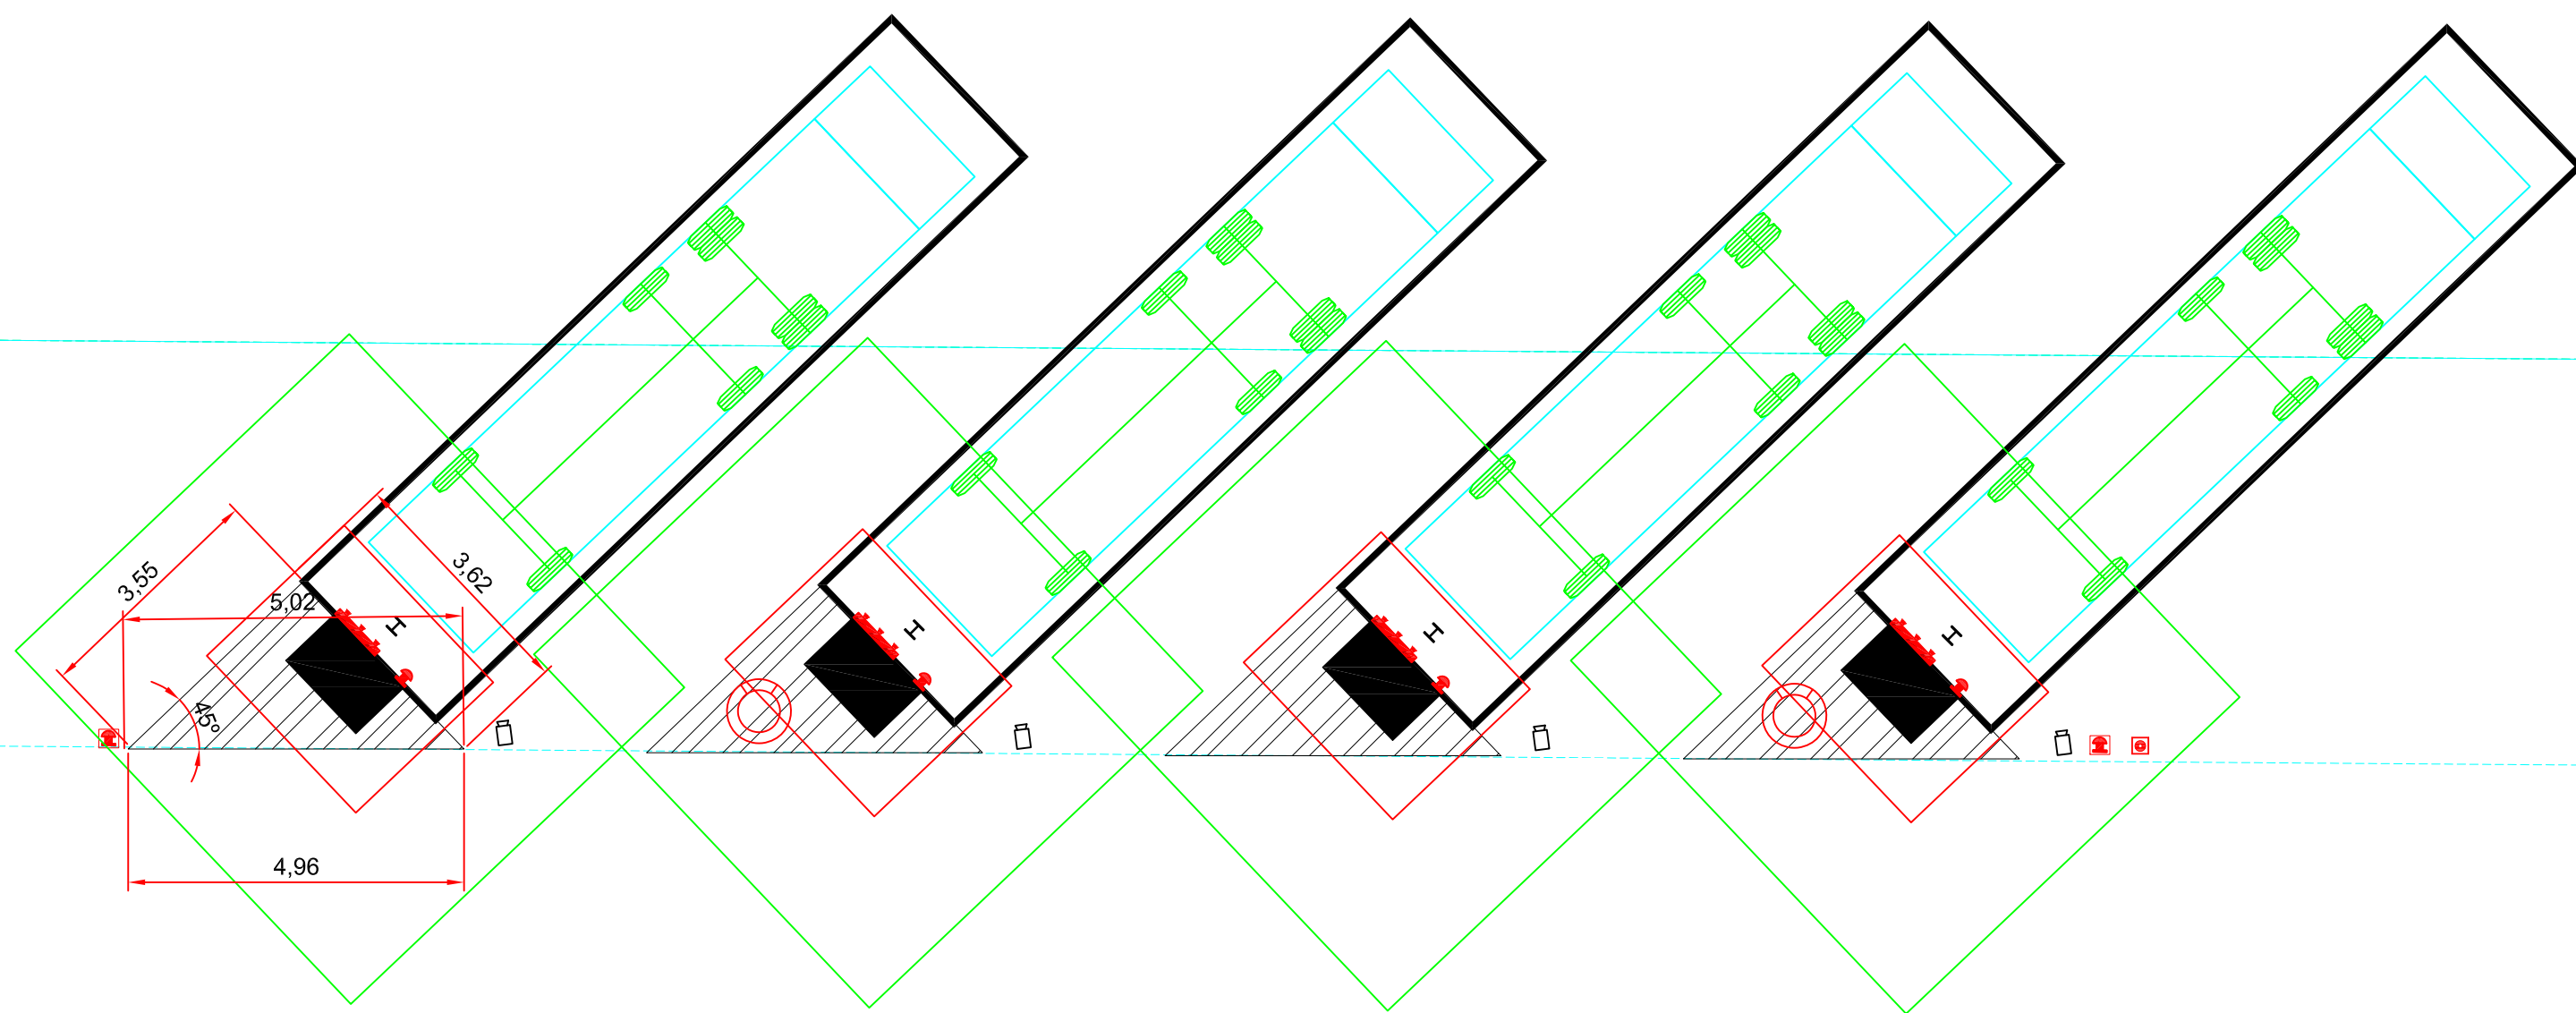


	PARADA DE EMERGENCIA
	ACT. MANUAL SISTEMA CONTRAINCENDIOS
	SISTEMA CONTRAINCENDIOS ISLETA
	PARADA EMERGENCIA GENERAL
	ALM. POLVO ABC SISTEMA CONTRAINCENDIOS
	LECTOR DE MATRICULAS


D					--	INTELLECTUAL PROPERTY: ALL RIGHTS RESERVED. DO NOT ALLOW THE USE OR THE TOTAL OR PARTIAL REPRODUCTION OF THIS DOCUMENT OR DISSEMINATION TO THIRD PARTIES WITHOUT PRIOR EXPRESS WRITTEN AUTHORIZATION.		REALIZED BY	CHECKED BY	APPROVED BY	APPROVED FOR CONSTRUCTION
C					--		NAME	--	--	--	--
B					--		DATE	--	--	--	--
A	FIRST EDITION	13/07/22	C.F	R.C	--						
REV.	DESCRIPTION	DATE	REALIZED BY	CHECKED BY	APPROVED BY	PROJECT AND TITLE OF DRAWING					
CONTROL OF CHANGES						31540001CP01 – ESTACIÓN GNC ZONA DE SUMINISTRO CON EDIFICIO (FASE 2)					
HAM CRIOGÉNICA,S.L. Pol. Ind. Sant Ermengol Parc. 11 08630 - ABRERA (Barcelona) www.ham.es T: +34 93 770 47 60		CUSTOMER MANCOMUNIDAD DE PAMPLONA		FORMAT A2	SCALE 1/100		PLANE NUMBER DWG_4_SUMINISTRO_2	SHEET 1 OF 1		REVIEW A	



Criogénica

Polígono Industrial Sant Emengol, parcela 11
08630 Abrera (Barcelona)
Tel. 93 770 47 60
Fax 93 770 34 41
ham@ham.es

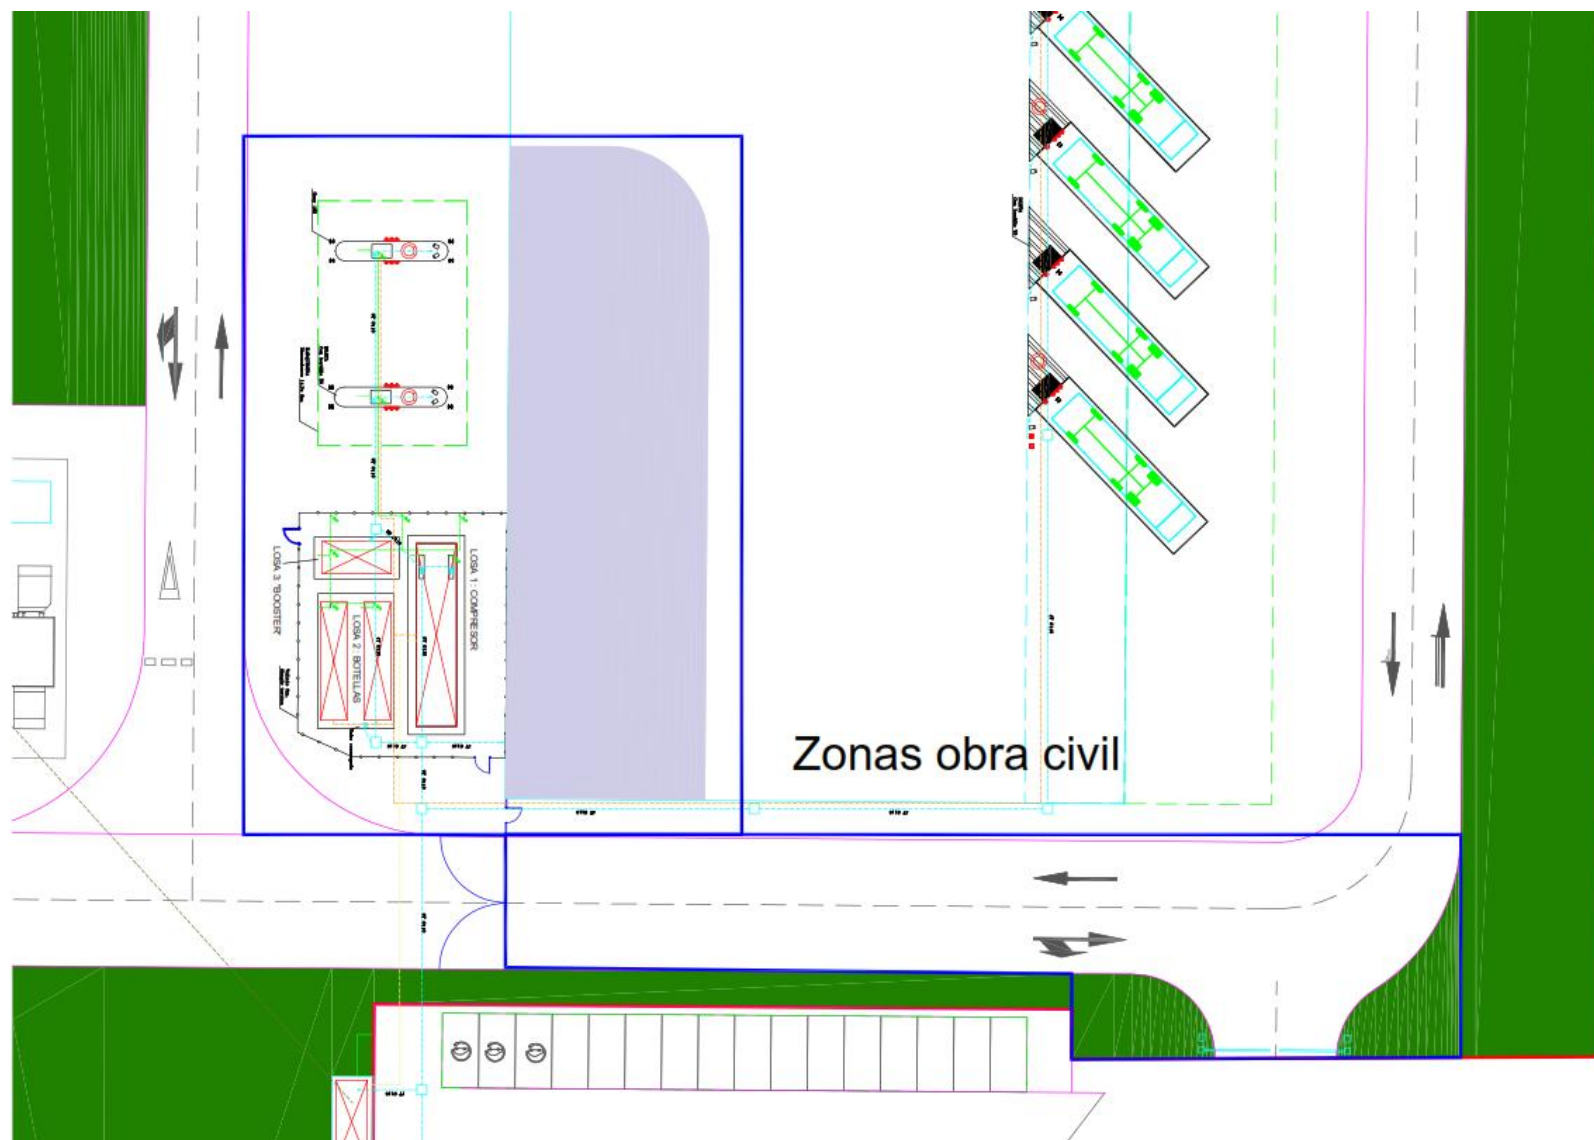

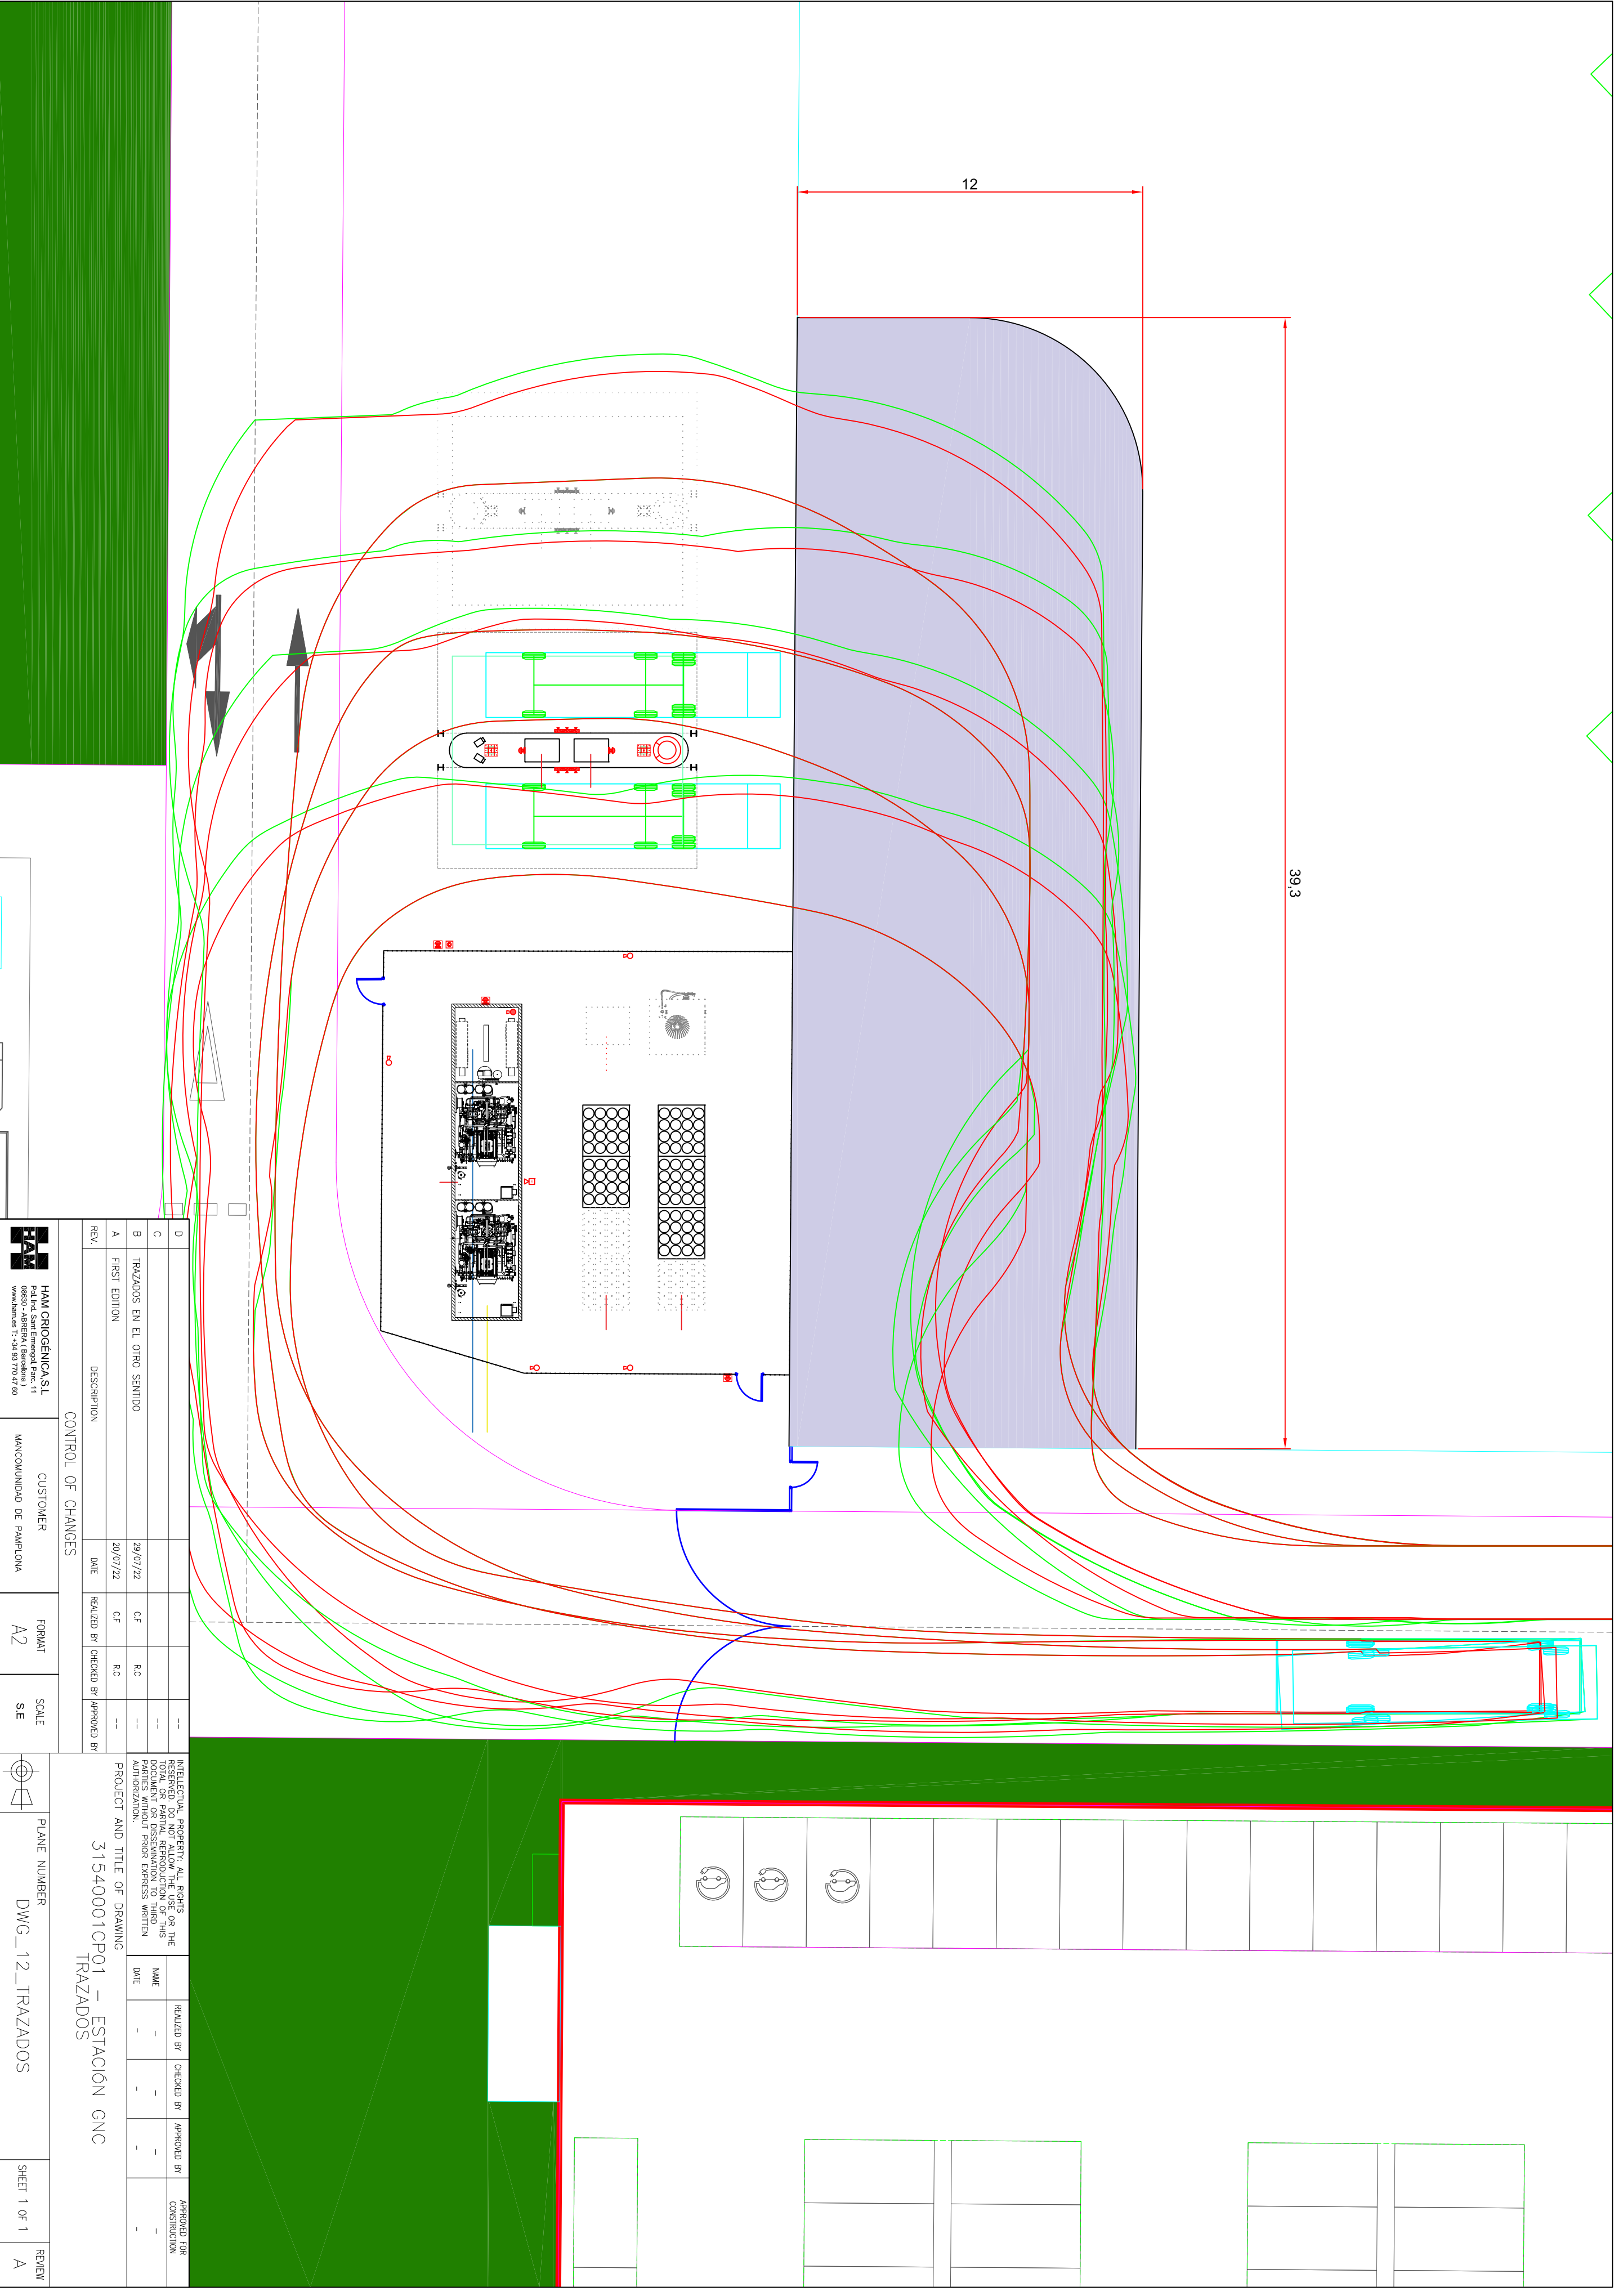

CONTROL OF CHANGES				CUSTOMER		FORMAT	SCALE	PLANE NUMBER				SHEET 1 OF 1		REVIEW
REV.	DESCRIPTION	DATE	REALIZED BY	CHECKED BY	APPROVED BY	APPROVED FOR CONSTRUCTION	NAME	DATE	NAME	DATE	NAME	DATE	NAME	DATE
D														
C	TRAZADOS EN EL OTRO SENTIDO	29/07/22	C.F.	R.C.										
B														
A	FIRST EDITION	20/07/22	C.F.	R.C.										

